

ADDENDUM # 01

DATE: March 19, 2025

ADDENDUM NO: 01

PROJECT: Evergreen Baptist Church – Phase 5

OWNER: Evergreen Baptist Church

ARCHITECT: Reed Architecture & Interior, LLC
18 East Hobson Avenue
Sapulpa, Oklahoma

TO: Lowry Construction Services
1729 S. Boston Ave.
Tulsa, OK 74119



Drawings and Specifications for the above noted project and the work covered thereby are herein modified as follows, and except as set forth herein, otherwise remain unchanged and in full force and effect. This addendum is part of the bidding documents for the above referenced project and modifies the original bidding documents dated March 03, 2025. Acknowledgement of receipt of this addendum is required as part of the Bid.

Addendum Narrative:

Clarifications:

1. Project Tax Status: Evergreen Baptist Church is Tax Exempt.

DRAWINGS:

ARCHITECTURAL:

1. AD100 – ARCHITECTURAL DEMO PLAN – FIRST FLOOR OVERALL; Expanded Second Floor Demo Plan.
2. A102.2 – SECOND FLOOR FINISH PLAN: Added Phase 3 Second Floor Finish Plan.
3. A601 – DOOR AND DOOR FRAME SCHEDULES AND DETAILS: Added door hardware information to schedules; Removed Access Control on doors (225, 226.1 & 226.2)
4. A604 – INTERIOR SCHEDULES: Revised CPT5 in the Finish & Material Legend.

Evergreen Baptist Church
Phase 5
Broken Arrow, Oklahoma

Addendum NO.1
March 19, 2025

Reed Architecture and Interiors
18 East Hobson Avenue
Sapulpa, Oklahoma

ADDENDUM # 01

SPECS:

1. Added Section – 08 7100 DOOR HARDWARE

---END OF ADDENDUM #01---

ARCHITECT: Reed Architecture & Interiors

By:

Brandon Gee

**SECTION 08 7100
DOOR HARDWARE**

Finish List

Code	Description
626	Satin Chromium Plated
AL	Aluminum (BHMA 689)
GRAY	Gray
SP28	Lacquer Sprayed Aluminum
US26D	Chromium Plated, Dull
US28	Aluminum - Clear Anodized
US32D	Stainless Steel, Dull

Set #13 - Not Used

Opening	Hdw Set
106	14
107	14
108	14
109	14
110	14
111	14
112	10
117	14
118	17
122	18
123	15
124	14
125	14
126	12
127	14
128	14
129	14
130	14
131	16
201	12
204	14
205	14
206	14
207	14
208	14
209	15
210	15
211	11
218	14
219	17
223	18
224	15
225	18
228	14
229	14
230	14
101.1	01
101.2	02
101.3	03
102.1	04
102.2	08
102.3	07
102.4	06
102.5	05
103.1	07
103.2	08
103.3	07

Opening	Hdw Set
103.4	06
103.5	06
104.1	03
104.2	02
104.3	03
114.1	14
114.2	15
115.1	11
115.2	09
116.1	12
116.2	09
226.1	18
226.2	18

Hardware Sets

Set #01

Doors: 101.1

1 Continuous Hinge	KCFM 83 HD1		PE
1 Exit Device	33A-EO	US28	VO
1 Electric Strike	6300	US32D	VO
1 Offset Door Pull	BF158 TYPE 1XHD FASTENING	US32D	RO
1 Operator	4642 REGARM	AL	LC
1 Push Button	8310-3856TWF		LC
1 Door Sweep	315 CN 36"		PE
1 Saddle Threshold	171 A 36"		PE

NOTE: Exterior Door Locked and Secured. Door released by card reader or timer. Auto Operator w/ Electric Strike activated by push button when released by access control. Free egress from Interior (Push) Side of Door.

Number of Openings: 1

Set #02

Doors: 101.2, 104.2

1 Continuous Hinge	KCFM 83 HD1		PE
1 Continuous Hinge	KCFM 83 HD1 SER8		PE
1 Exit Device	3349A-EO 48"	US28	VO
1 Exit Device	QEL 3349A-NL-OP x 388 48"	US26D,	VO
		US28	
1 IC Rim Cylinder	20-057 ICX	626	SC
2 Interchangeable Core	23-030 C KEYWAY	626	SC
2 Offset Door Pull	BF158 TYPE 1XHD FASTENING	US32D	RO
2 Closer	4040XP SCUSH 30 SHOE SUPPORT 4040-18PA	AL	LC
	61 STOP SPACER TBSRT		
1 Power Supply	PS902 900-2RS		LO
1 Wire Harness	CON-12P		SC
2 Door Bottom	315 CN 48"		PE
1 Threshold	171 A 96"		PE

NOTE: Exterior Doors Locked and Secured. Exit Device Released by Access Control. Free Egress from Interior Side of Door

Number of Openings: 2

Set #03

Doors: 101.3, 104.1, 104.3

1 Continuous Hinge	KCFM 83 HD1		PE
1 Exit Device	33A-EO	US28	VO
1 Offset Door Pull	BF158 TYPE 1XHD FASTENING	US32D	RO
1 Closer	4040XP SCUSH 30 SHOE SUPPORT 4040-18PA	AL	LC
	61 STOP SPACER TBSRT		
1 Door Sweep	315 CN 36"		PE
1 Saddle Threshold	171 A 36"		PE

Number of Openings: 3

Set #04

Doors: 102.1

2 Continuous Hinge	KCFM 83 HD1		PE
2 Push/Pull Bar	BF15847 33" T1HD Mounting	US32D	RO
NOTE: Door Type Aluminum, Push Bar 33" CTC			
2 Operator	4642 REGARM	AL	LC
1 Push Button	8310-3856TWF		LC

Number of Openings: 1

Set #05

Doors: 102.5

1 Continuous Hinge	KCFM 83 HD1		PE
1 Continuous Hinge	KCFM 83 HD1 SER8		PE
1 Key Removable Mullion	KR4954 7'6"	SP28	VO
1 Exit Device	33A-EO	US28	VO
1 Exit Device	QEL 33A-NL x 386NL	US26D, US28	VO
1 IC Rim Cylinder	20-057 ICX	626	SC
1 Interchangeable Core	23-030 C KEYWAY	626	SC
2 Offset Door Pull	BF158 TYPE 1XHD FASTENING	US32D	RO
1 Power Supply	PS902 900-2RS		LO
1 Wire Harness	CON-12P		SC
2 Door Sweep	315 CN 36"		PE
1 Threshold	171 A 73"		PE

NOTE: Exterior Doors Locked and Secured. Exit Device Released by Access Control. Free Egress from Interior Side of Door

Number of Openings: 1

Set #06

Doors: 102.4, 103.4, 103.5

2 Continuous Hinge	KCFM 83 HD1		PE
1 Key Removable Mullion	KR4954 7'6"	SP28	VO
1 Exit Device	33A-NL-OP x 388	US26D, US28	VO
1 Exit Device	33A-EO	US28	VO
1 IC Rim Cylinder	20-057 ICX	626	SC
1 Interchangeable Core	23-030 C KEYWAY	626	SC
2 Closer	4040XP SCUSH 30 SHOE SUPPORT 4040-18PA	AL	LC
	61 STOP SPACER TBSRT		
2 Door Sweep	315 CN 36"		PE
1 Threshold	171 A 73"		PE

Number of Openings: 3

Set #07

Doors: 102.3, 103.1, 103.3

1 Continuous Hinge	KCFM 83 HD1		PE
1 Push/Pull Bar	BF15847 33" T1HD Mounting	US32D	RO
NOTE: Door Type Aluminum, Push Bar 33" CTC			
1 Closer	4040XP SCUSH 30 SHOE SUPPORT 4040-18PA	AL	LC
	61 STOP SPACER TBSRT		

Number of Openings: 3

Set #08

Doors: 102.2, 103.2

2 Continuous Hinge	KCFM 83 HD1		PE
2 Push/Pull Bar	BF15847 45" T1HD Mounting	US32D	RO
2 Closer	4040XP SCUSH 30 SHOE SUPPORT 4040-18PA	AL	LC
	61 STOP SPACER TBSRT		

Number of Openings: 2

Set #09

Doors: 115.2, 116.2

5 Hinges	5BB1 HW 4 1/2 x 4 1/2	626	IV
1 Hinges	5BB1 HW 4 1/2 x 4 1/2 CON TW8	626	IV
1 Key Removable Mullion	KR4954 7'6"	SP28	VO
1 Exit Device	99L x 996L-R&V	US26D,	VO
		US28	
1 Exit Device	QEL 99L x 996L-R&V	US26D,	VO
		US28	
1 Mortise Cylinder	26-091	626	SC
1 IC Rim Cylinder	20-057 C KEYWAY	626	SC
2 Closer	4040XP SHCUSH TBSRT	AL	LC
2 Protection Plate	K1050 10" x 34"	US32D	RO
1 Power Supply	PS902 900-2RS		LO
1 Wire Harness	CON-12P		SC
1 Overhead Drip Cap	346 C 76"		PE
1 Mullion Gasketing	5110 BL 120"		PE
1 Weatherstrip	306 AV 1 x 72" 2 x 84"		PE
2 Door Sweep	315 CN 36"		PE
1 Threshold	171 A 73"		PE

NOTE: Exterior Doors Locked and Secured. Exit Device Released by Access Control. Free Egress from Interior Side of Door

Number of Openings: 2

Set #10

Doors: 112

3 Hinges	5BB1 4 1/2 x 4 1/2 NRP	626	IV
1 Exit Device	99L x 996L-R&V	US26D, US28	VO
1 IC Rim Cylinder	20-057 ICX	626	SC
1 Interchangeable Core	23-030 C KEYWAY	626	SC
1 Closer	4040XP SCUSH	AL	LC
1 Protection Plate	K1050 10" x 34"	US32D	RO
1 Weatherstrip	306 AV 1 x 36" 2 x 84"		PE
1 Door Bottom	315 CN 48"		PE
1 Saddle Threshold	171 A 36"		PE

Number of Openings: 1

Set #11

Doors: 115.1, 211

6 Hinges	5BB1 HW 4 1/2 x 4 1/2	626	IV
2 Exit Device	9927L-F x 996L-R&V LBR	US26D, US28	VO
2 Exit Device	9927L-F x 996L-R&V LBRAFL	US26D, US28	VO
2 IC Rim Cylinder	20-057 ICX	626	SC
2 Interchangeable Core	23-030	626	SC
NOTE: Verify Existing Key System.			
2 Closer	4040XP RWPA	AL	LC
2 Protection Plate	K1050 10" x 34"	US32D	RO
2 Gasketing	S88 D 21'		PE

Number of Openings: 2

Set #12

Doors: 116.1, 126, 201

5 Hinges	5BB1 HW 4 1/2 x 4 1/2	626	IV
1 Hinges	5BB1 HW 4 1/2 x 4 1/2 CON TW8	626	IV
1 Exit Device	9927L-F x 996L-R&V LBR	US26D, US28	VO
1 Exit Device	QEL 9927L x 996L-R&V LBR	US26D, US28	VO
2 IC Rim Cylinder	20-057 ICX	626	SC
2 Interchangeable Core	23-030 C KEYWAY	626	SC
2 Closer	4040XP SHCUSH TBSRT	AL	LC
2 Protection Plate	K1050 10" x 34"	US32D	RO
1 Gasketing	S88 D 21'		PE

NOTE: Exterior Doors Locked and Secured. Exit Device Released by Access Control. Free Egress from Interior Side of Door. Remote Release by Others on Doors 126 & 116.1

Number of Openings: 3

Set #13**Not Used**Number of Openings: **0****Set #14**

Doors: 106, 107, 108, 109, 110, 111, 114.1, 117, 124, 125, 127, 128, 129, 130, 204, 205, 206, 207, 208, 218, 228, 229, 230

3 Hinges	5BB1 4 1/2 x 4 1/2	626	IV
1 Lockset	ND53P RHO C KEYWAY	626	SC
1 Wall Stop	409	US32D	RO
3 Door Silencer	608-RKW	GRAY	RO

Number of Openings: **23****Set #15**

Doors: 114.2, 123, 209, 210, 224

3 Hinges	5BB1 4 1/2 x 4 1/2	626	IV
1 Lockset	ND80P RHO C KEYWAY	626	SC
1 Wall Stop	409	US32D	RO
3 Door Silencer	608-RKW	GRAY	RO

Number of Openings: **5****Set #16**

Doors: 131

3 Hinges	5BB1 4 1/2 x 4 1/2	626	IV
1 Lockset	ND80P RHO C KEYWAY	626	SC
1 Closer	1461 RWPA FPC TBSRT	AL	LC
1 Protection Plate	K1050 10" x 34"	US32D	RO
1 Gasketing	S88 D 17'		PE

Number of Openings: **1****Set #17**

Doors: 118, 219

3 Hinges	5BB1 4 1/2 x 4 1/2	626	IV
1 Lever set	ND40 RHO OS-OCC	626	SC
1 Wall Stop	409	US32D	RO
3 Door Silencer	608-RKW	GRAY	RO

Number of Openings: **2**

Set #18

Doors: 122, 223, 225, 226.1, 226.2

3 Hinges	5BB1 4 1/2 x 4 1/2 NRP	626	IV
1 Electronic Lock	CO-100-CY-70-KP-RHO	626	LO
1 Closer	1461 RWPA FPC TBSRT	AL	LC
1 Protection Plate	K1050 10" x 34"	US32D	RO
3 Door Silencer	608-RKW	GRAY	RO

NOTE: Lock always secured, entry by code or key override. Free egress from interior.

Number of Openings: **5**

Total Number of Openings: **60**


FLOOR PLAN DEMOLITION NOTES	
MARK	NOTE
01	REMOVE EXISTING EXTERIOR PEMB WALL GIRTS AND PANELS
02	REMOVE EXISTING STOREFRONT
03	REMOVE EXISTING INTERIOR WALL
04	REMOVE EXISTING PEMB CANOPY METAL FRAMING AND FOUNDATIONS
05	REMOVE EXISTING PEMB CANOPY ROOF AND GUTTER SYSTEM
06	REMOVE EXISTING PEMB FRAMING
07	REMOVE EXISTING GUARD RAILS
08	REMOVE EXISTING ROOF TRIM
09	REMOVE EXISTING FLOOR FINISH AND RUBBER BASE
10	REMOVE EXISTING REFLECTED CEILING PLAN AS REQUIRED
11	REMOVE EXISTING EXTERIOR PEMB WALL PANELS




REED ARCHITECTURE & INTERIORS
"The Team You Trust"

This document, and the ideas and designs incorporated herein, as an instrument of professional service, is the property of REED Architecture & Interiors and is not to be used, in whole or in part, for any other project, without the written authorization of REED Architecture & Interiors.
© 2021 Reed Architecture & Interiors


CONSULTANT:
Reference Cover Sheet
for Consultant Directory

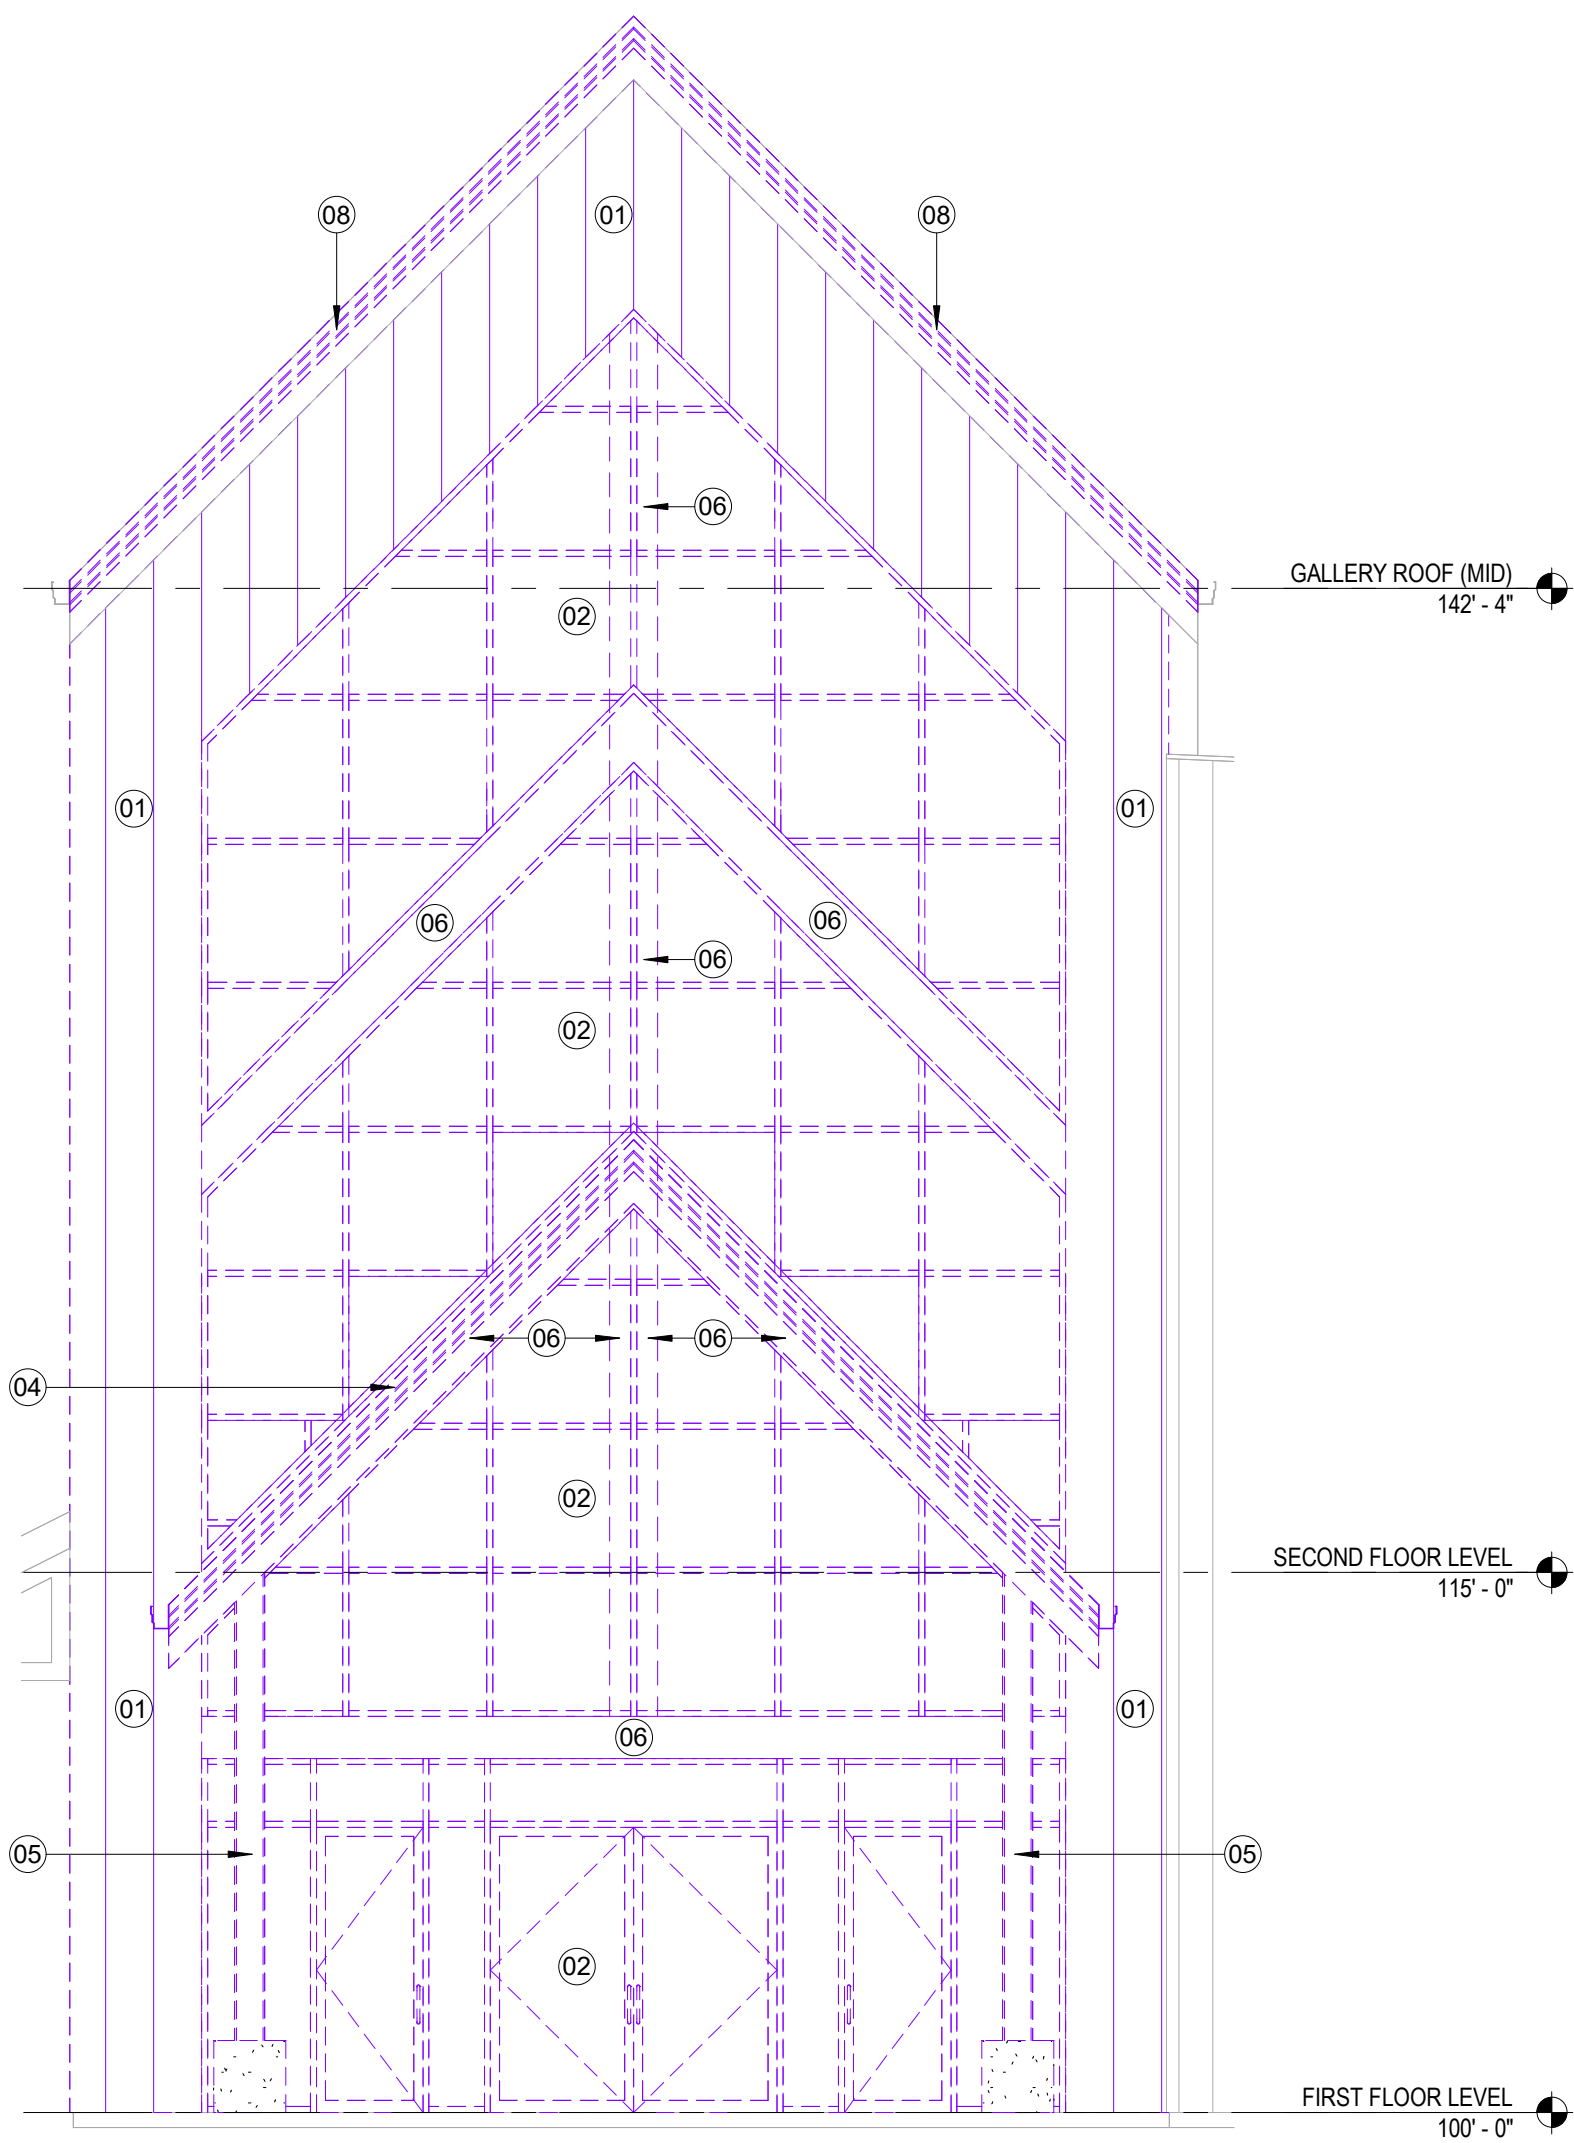

3 DEMO ELEVATION
3/16" = 1'-0"

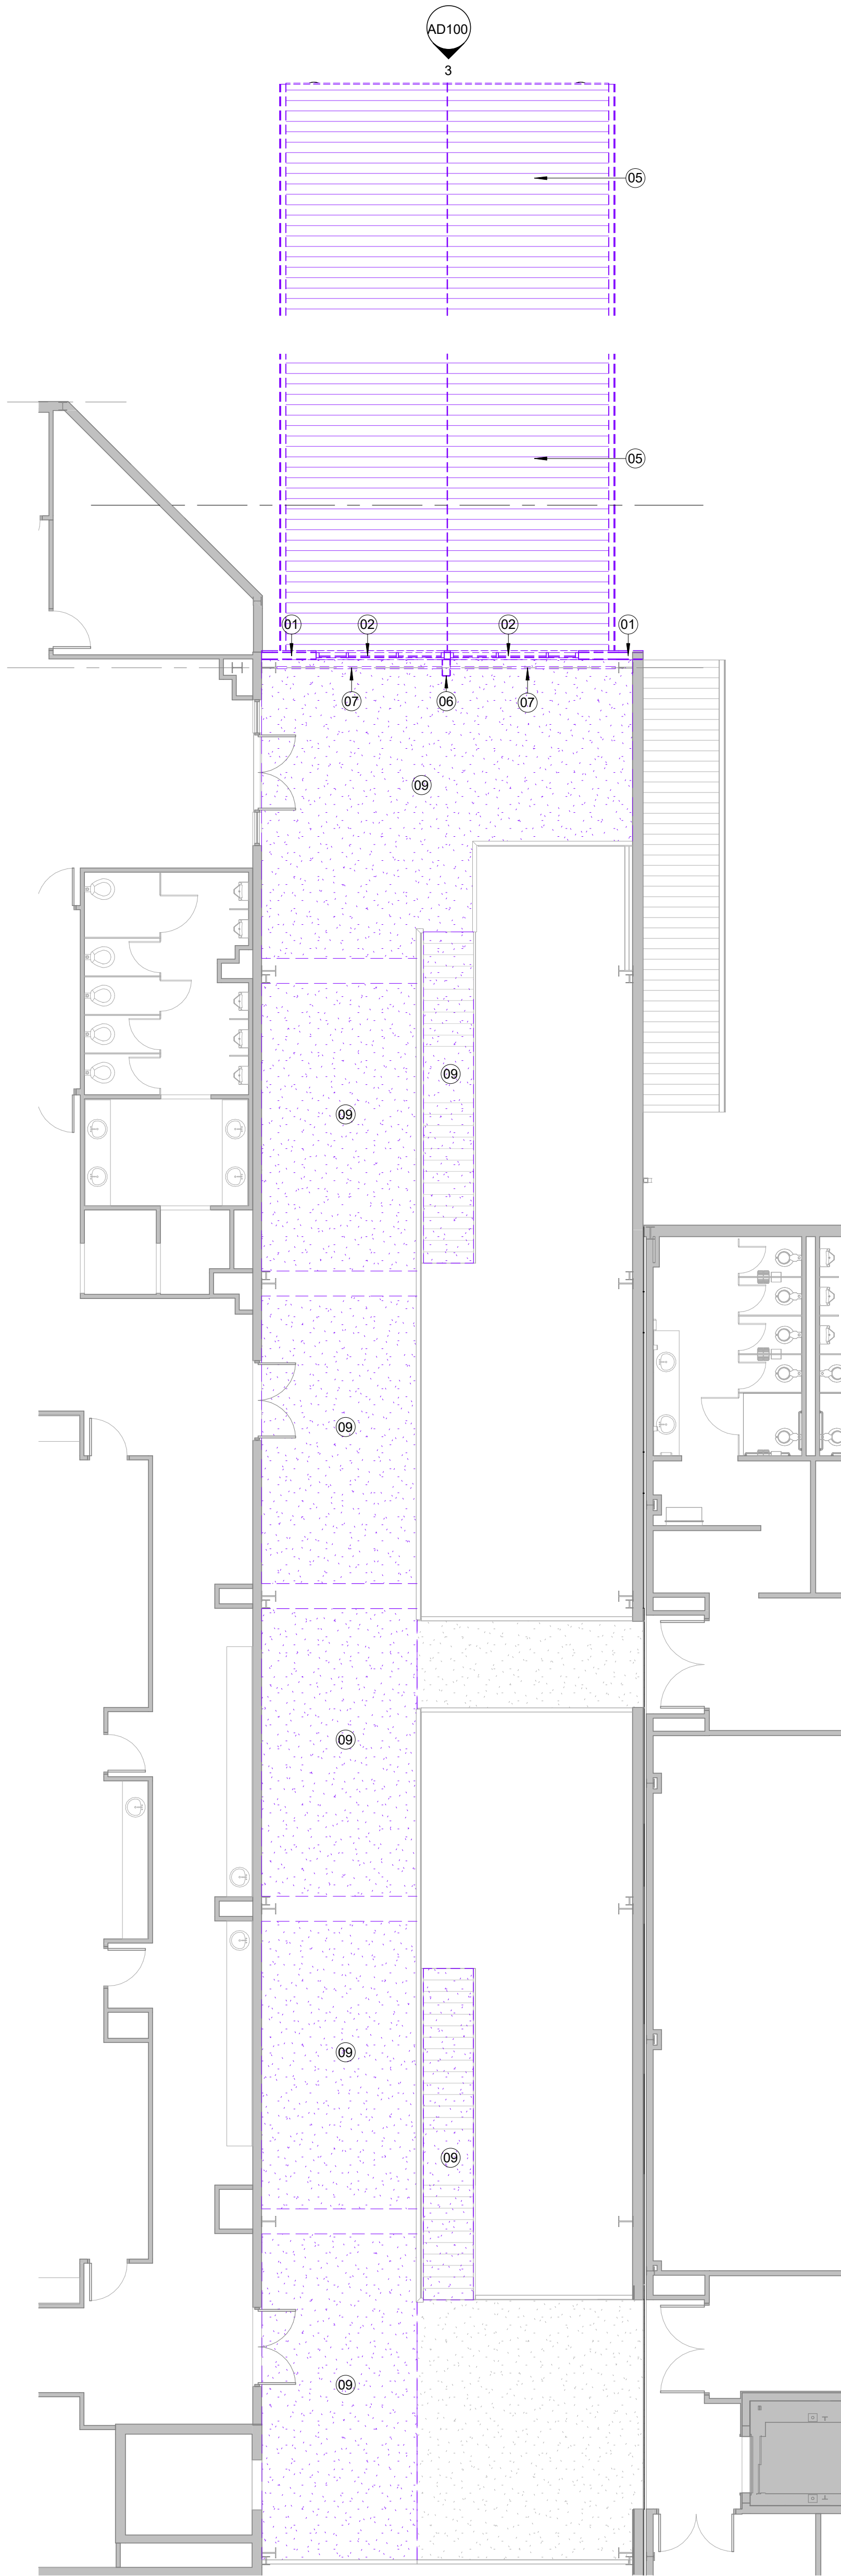

2 SECOND FLOOR LEVEL DEMO
1/8" = 1'-0"

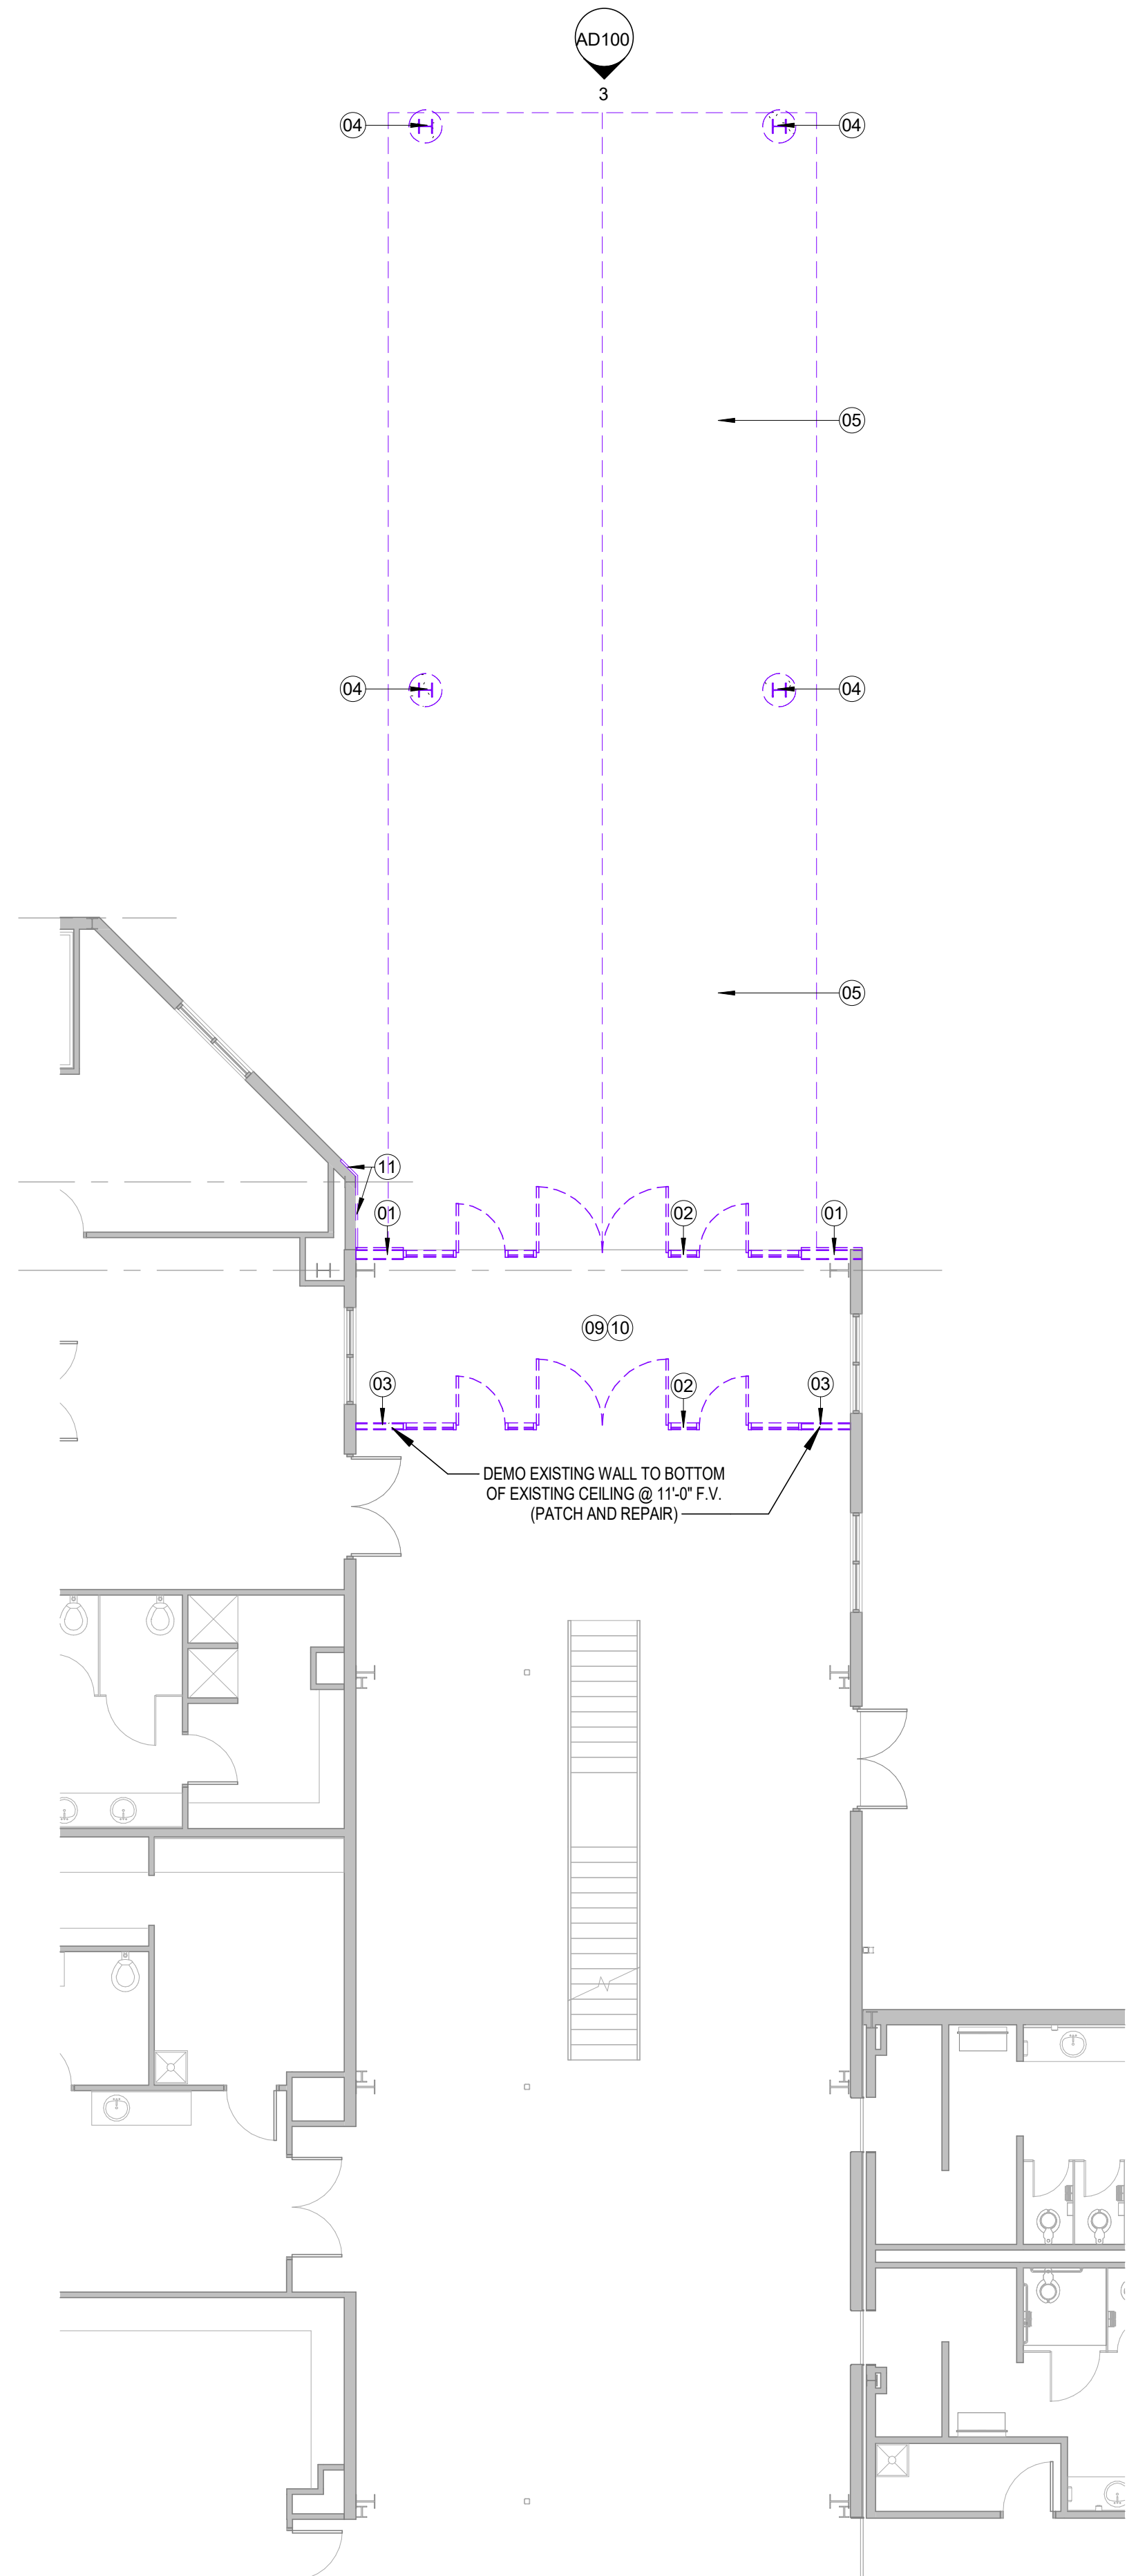

1 FIRST FLOOR LEVEL DEMO
1/8" = 1'-0"

100% CONSTRUCTION
DOCUMENTS
03.03.2025

**EVERGREEN BAPTIST
CHURCH - PHASE 5**


10301 EAST 111TH ST. S.
BROKEN ARROW, OKLAHOMA 74011

REVISIONS	
1	03.19.2025 ADD#1

ARCHITECTURAL DEMO PLAN –
FIRST FLOOR OVERALL


JOB 2023.14
ISSUE 03.03.2025
DRAWN BY: BG
CHKD BY: SE

 AD100
SCALE As indicated



MATERIALS LEGEND

RE: SPECIFICATIONS, FLOOR FINISH PLAN AND ROOM FINISH SCHEDULE FOR LOCATIONS

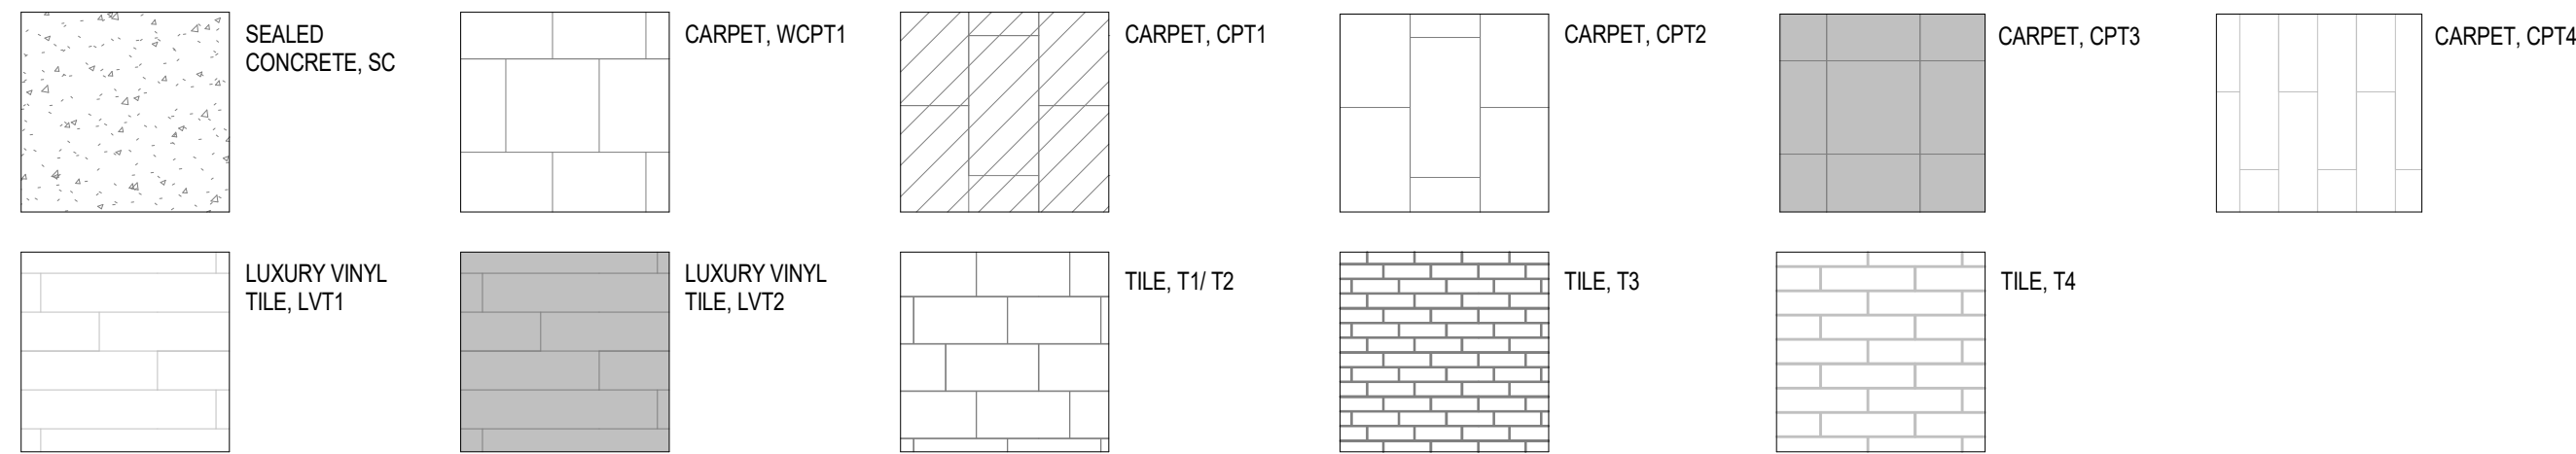


INTERIORS / FINISHES NOTES

- REFER TO NORTH DIRECTIONAL ARROWS ON PLANS.
- HOLLOW METAL DOORS/FRAMES & INTERIOR WINDOW FRAMES (NEW & EXISTING) SHALL BE PAINTED PT2, UNLESS OTHERWISE NOTED.
- ALL FINISHES IN EXITS SHALL BE CLASS A RATED. ALL FINISHES IN CORRIDORS SHALL BE CLASS A OR CLASS B RATED.
- THE FOLLOWING SHALL BE PAINTED UNLESS OTHERWISE STATED:
 - EXPOSED SPRINKLER PIPING, ELECTRICAL CONDUIT, AND WIRE MOLDING IN FINISHED AREAS.
 - EXPOSED DUCTWORK IN FINISHED AREAS.
 - EXPOSED BEAMS, JOISTS, DECK, AND COLUMNS IN FINISHED AREAS.
 - INTERIOR UNTELS.
 - INTERIOR HANDRAILS & GUARDRAILS.
 - INTERIOR STEEL LADDERS, EP-PT1, TYP.
 - EXPOSED CEILING IN ROOM 227 TO BE PAINTED PT9 ABOVE 11'-7".
- EXPOSED CEILINGS SHALL BE PAINTED PT1, UNLESS OTHERWISE NOTED. REFER TO INTERIOR / FINISH PLANS FOR FLOOR FINISH PATTERNS AND DETAILS.
- REFER TO INTERIOR ELEVATIONS FOR ADDITIONAL WALL FINISH INFORMATION.
- CEILING, FLOORS, AND WALLS IN FOOD PREPARATION AND SERVING AREAS SHALL BE WASHABLE.
- PAINT EXPOSED COLUMNS, TO MATCH ADJACENT WALLS, UNLESS OTHERWISE NOTED.
- PAINT PT6 AT ALL EXPOSED SURFACES AND EDGES OF BALCONY AND STAIR GUARD RAIL, HANDRAIL, STRINGERS, AND UNDERSIDE OF TREADS AND RISERS.
- NO EXPOSED RAW TILE EDGES. REFER TO FINISH & MATERIAL LEGEND FOR TRANSITIONS.
- WATERJET CUT LVT FLOORING AT CLASSROOM ENTRANCES AND CHECK-IN FOR SEAMLESS CURVED DESIGN.


INTERIORS COMMENTS

- INSTALL LVT14 DROP.
- INSTALL CARPET BASKETWEAVE.
- INSTALL CARPET ASHLAR.
- INSTALL CARPET BRICK.
- INSTALL FLOOR TILE 1/3 OFFSET.

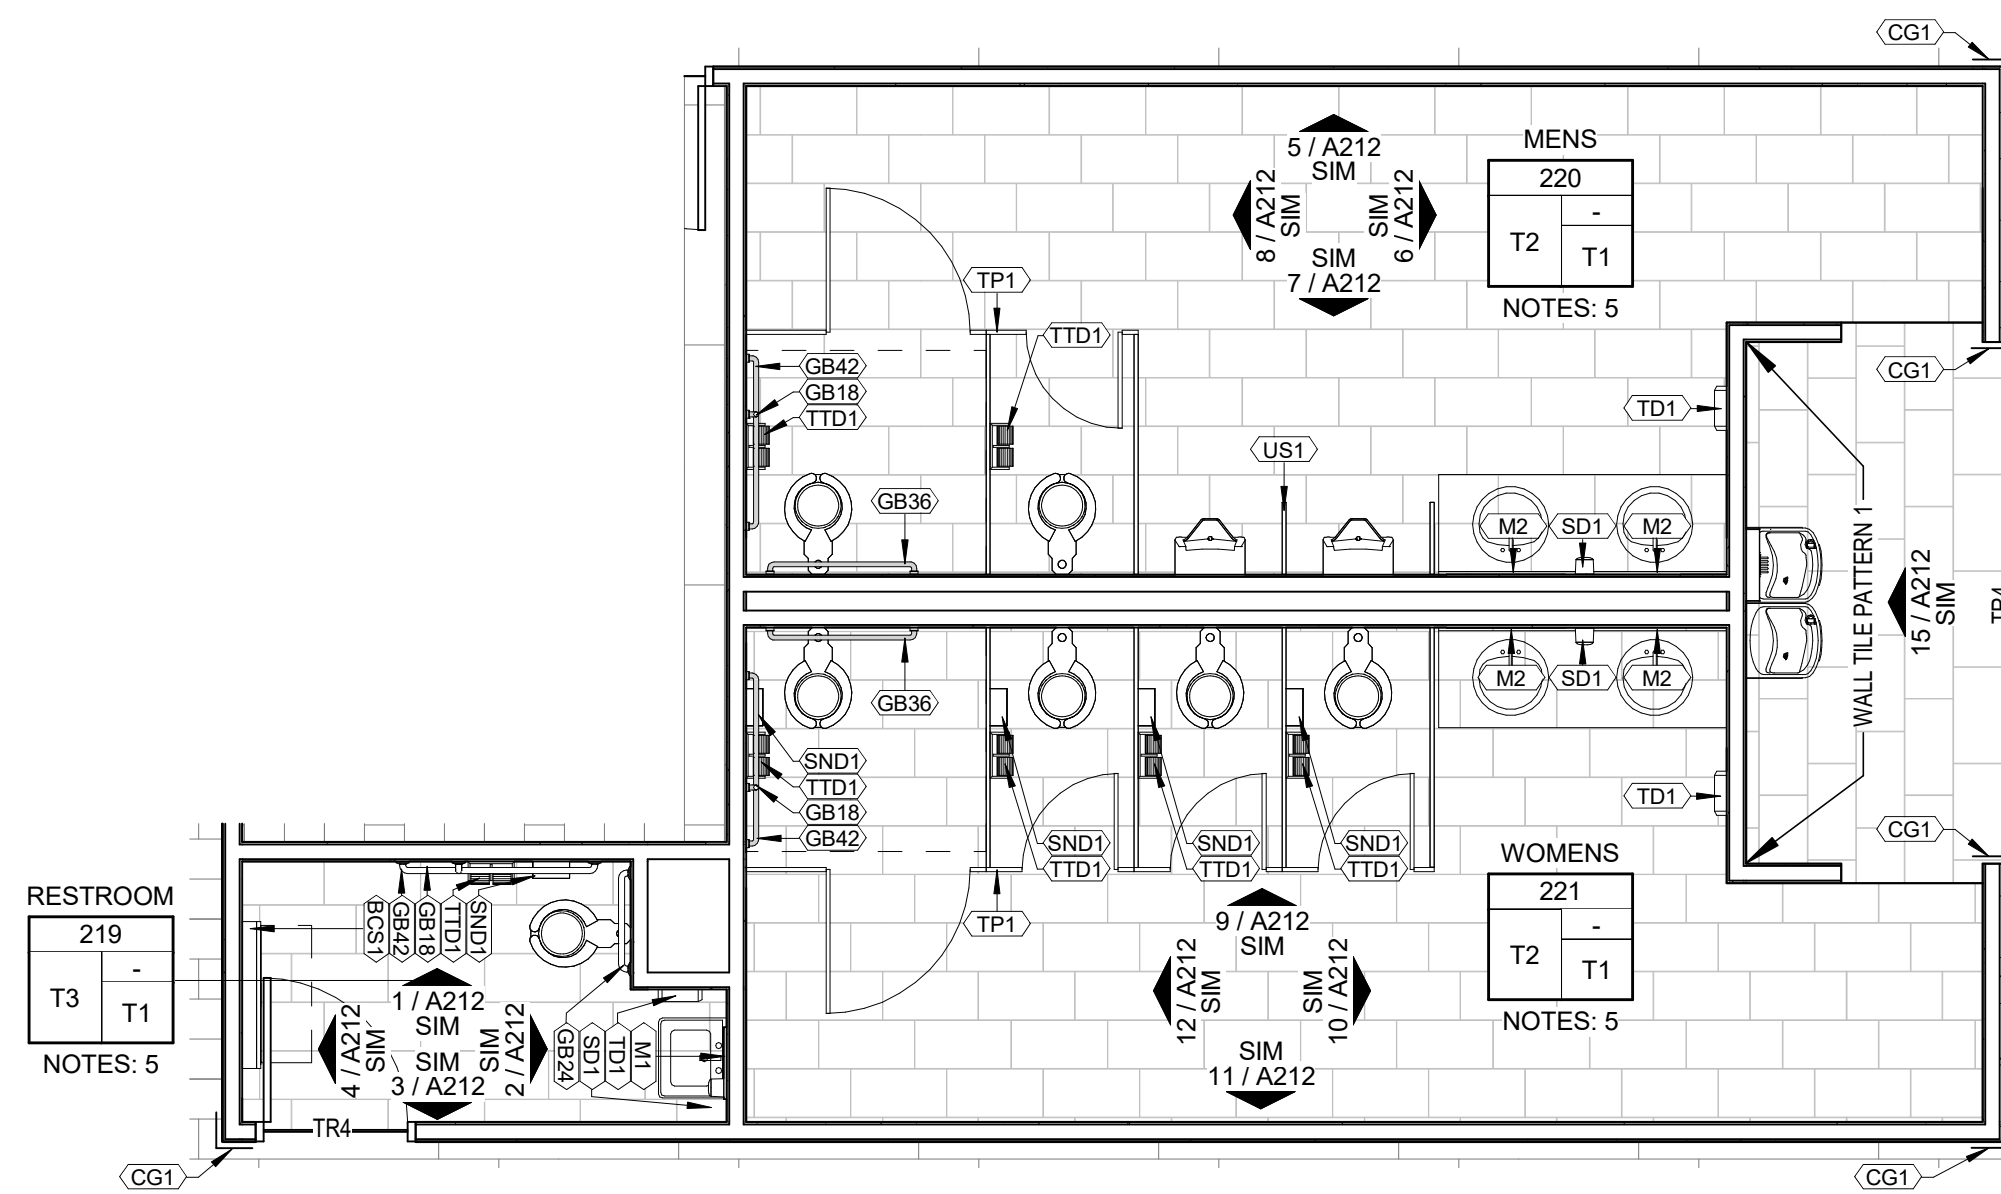

2 ENLARGED RESTROOM FINISH PLAN 219, 220, 221

1/4" = 1'-0" 1/4" A102.2

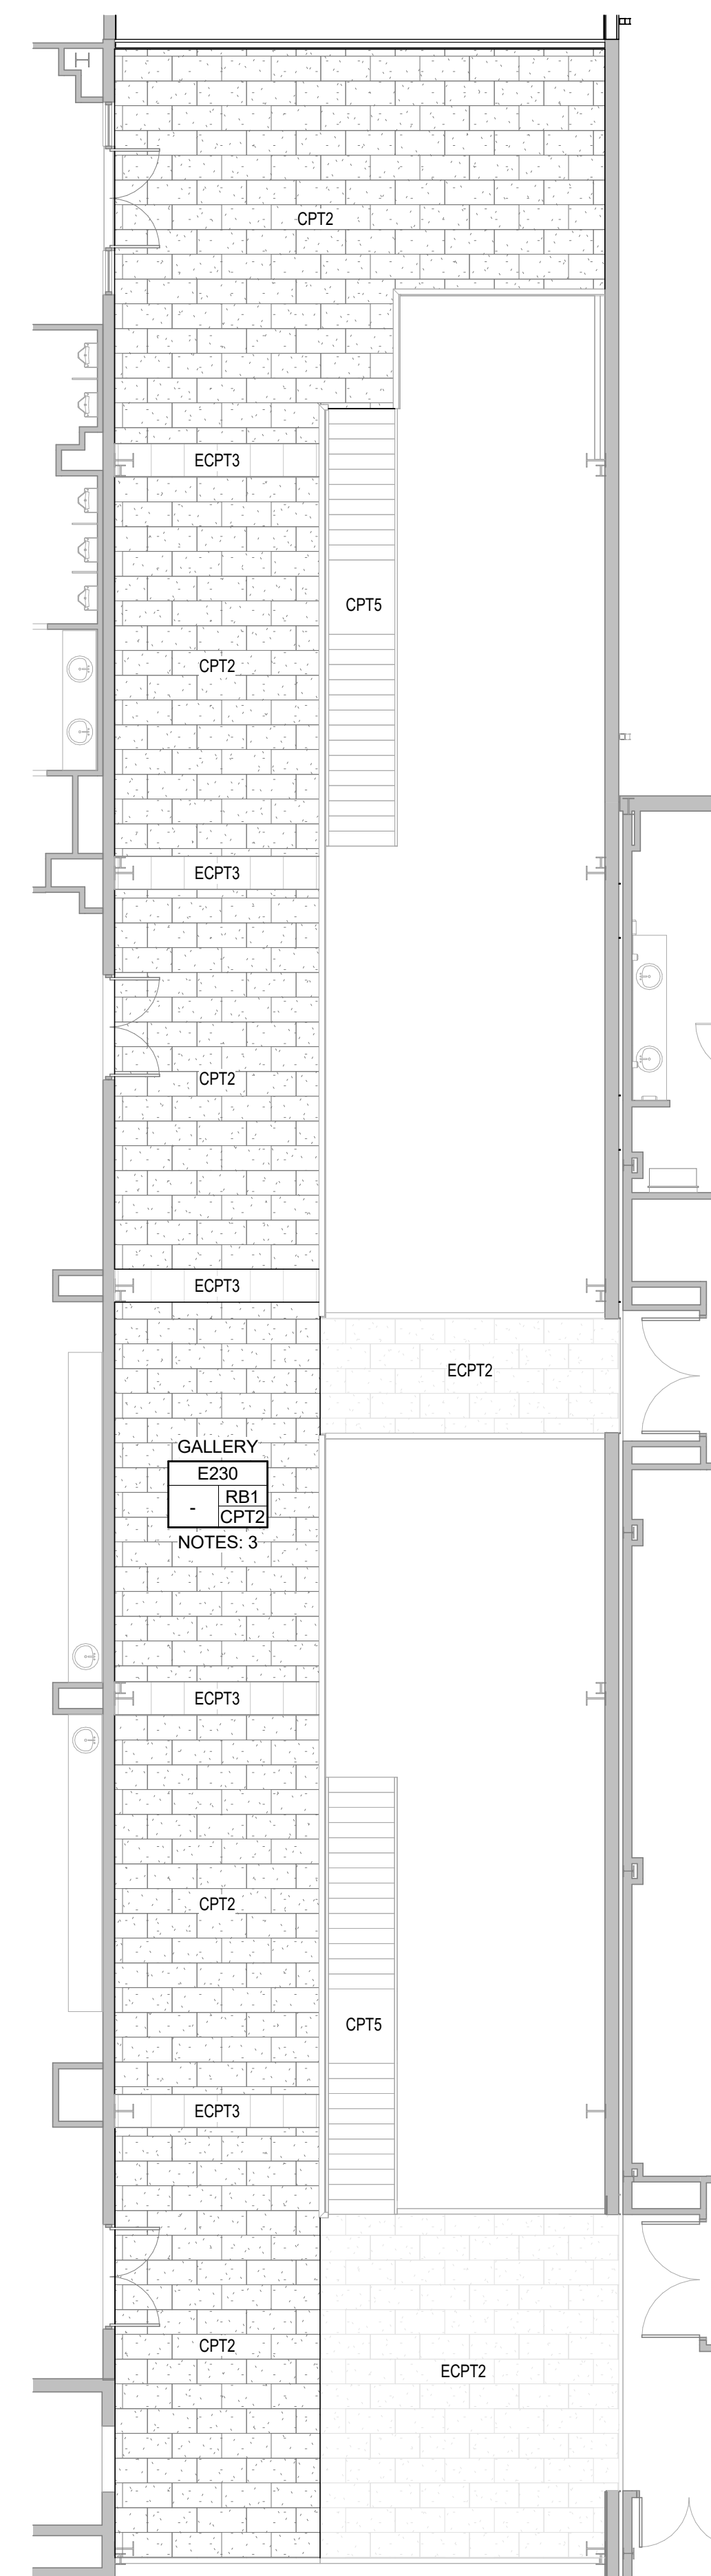

3 SECOND FLOOR FINISH PLAN -PHASE 3

1/8" = 1'-0"



1 SECOND FLOOR FINISH PLAN

1/8" = 1'-0"

100% CONSTRUCTION
DOCUMENTS
03.03.2025

EVERGREEN BAPTIST CHURCH - PHASE 5

10301 EAST 111TH ST. S.
BROKEN ARROW, OKLAHOMA 74011

REVISIONS

1 03.19.2025 ADD#1

SECOND FLOOR FINISH PLAN


JOB 2023.14
ISSUE 03.03.2025
DRAWN BY: MW
CHKD BY: BG

A102.2


SCALE As indicated

DOOR AND FRAME SCHEDULE - SECOND FLOOR

DOOR NO.	PAIR / SINGLE	DOOR IDENTIFICATION		DOOR CONSTRUCTION			FRAME CONSTRUCTION			FIRE RATING	DOOR / FRAME DETAILS			GLAZING TYPE	HW SET	OPERATOR	ACCESS CONTROL	COMMENTS
		WIDTH	HEIGHT	TYPE	MATERIAL	FINISH	TYPE	MATERIAL	FINISH		HEAD	JAMB	SILL					
SECOND FLOOR LEVEL																		
201	PR	6'-0"	7'-0"	4	WD	BIRCH NAT	A	HM	60	2/A601	1/A601	-		12	• PANIC HARDWARE			
204		3'-0"	7'-0"	2	WD	BIRCH NAT	A	HM		2/A601	1/A601	-	14					
205		3'-0"	7'-0"	2	WD	BIRCH NAT	A	HM		2/A601	1/A601	-	14					
206		3'-0"	7'-0"	3	WD	BIRCH NAT	A	HM		2/A601	1/A601	-	14					
207		3'-0"	7'-0"	3	WD	BIRCH NAT	A	HM		2/A601	1/A601	-	14					
208		3'-0"	7'-0"	3	WD	BIRCH NAT	A	HM		2/A601	1/A601	-	14					
209		3'-0"	7'-0"	1	WD	BIRCH NAT	A	HM		2/A601	1/A601	-	15					
210		3'-0"	7'-0"	1	WD	BIRCH NAT	A	HM		2/A601	1/A601	-	15					
211		6'-0"	7'-0"	2	HM		A	HM		2/A601	1/A601	-	11	PANIC HARDWARE				
216		3'-0"	7'-0"	1	WD	BIRCH NAT	A	HM		2/A601	1/A601	-	14					
218	3'-0"	7'-0"	1	WD	BIRCH NAT	A	HM	2/A601	1/A601	-	17							
223	3'-0"	7'-0"	1	WD	BIRCH NAT	A	HM	2/A601	1/A601	-	18							
224	3'-0"	7'-0"	1	WD	BIRCH NAT	A	HM	2/A601	1/A601	-	15							
225	3'-0"	7'-0"	1	WD	BIRCH NAT	A	HM	2/A601	1/A601	-	18							
226.1	3'-0"	7'-0"	3	WD	BIRCH NAT	A	HM	2/A601	1/A601	-	18							
226.2	3'-0"	7'-0"	3	WD	BIRCH NAT	A	HM	2/A601	1/A601	-	18							
228	3'-0"	7'-0"	3	WD	BIRCH NAT	A	HM	2/A601	1/A601	-	14							
229	3'-0"	7'-0"	3	WD	BIRCH NAT	A	HM	2/A601	1/A601	-	14							
230	3'-0"	7'-0"	3	WD	BIRCH NAT	A	HM	2/A601	1/A601	-	14							

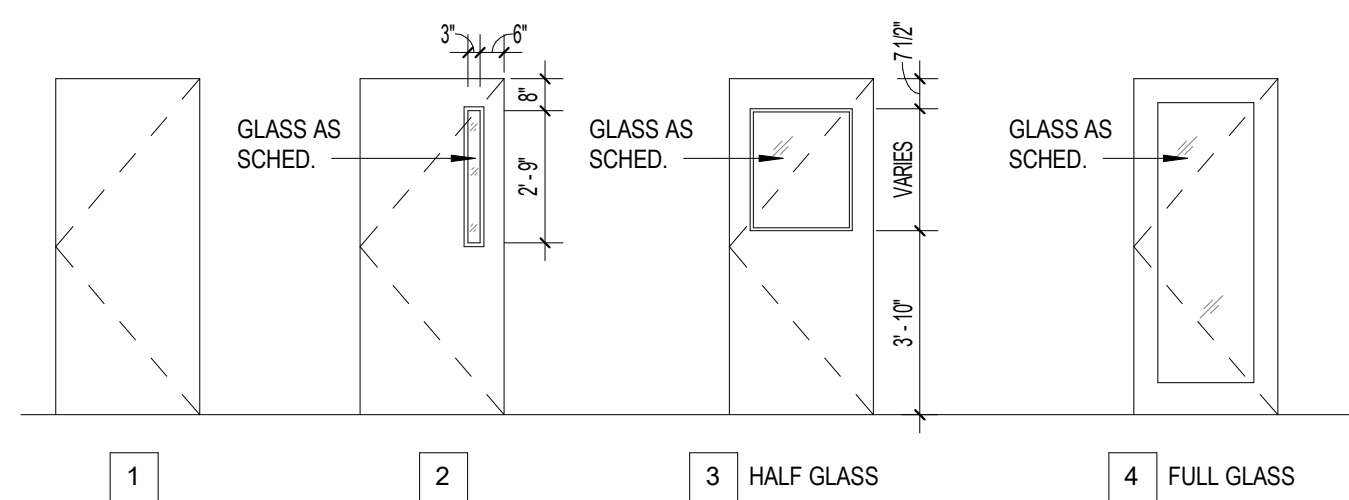


DOOR TYPES

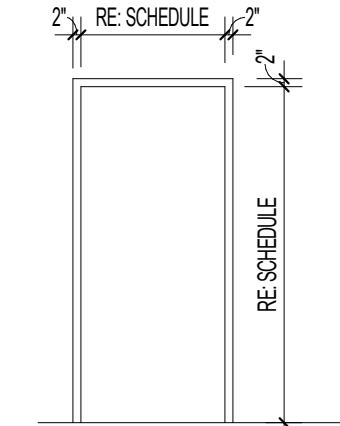


FRAME TYPES

DOOR AND FRAME SCHEDULE - FIRST FLOOR


DOOR NO.	DOOR IDENTIFICATION		DOOR CONSTRUCTION			FRAME CONSTRUCTION			FIRE RATING	DOOR / FRAME DETAILS			GLAZING TYPE	HW SET	OPERATOR	ACCESS CONTROL	COMMENTS
	PAIR / SINGLE	SIZE	TYPE	MATERIAL	FINISH	TYPE	MATERIAL	FINISH		HEAD	JAMB	SILL					
FIRST FLOOR LEVEL																	
101.1		3'-0"	7'-0"	4	ALUM		A	ALUM		10/A602	7/A601	6/A601		01			PANIC HARDWARE
101.2	PR	8'-0"	7'-0"	4	ALUM		A	ALUM		10/A602	7/A601	6/A601		02		•	PANIC HARDWARE
101.3		3'-0"	7'-0"	4	ALUM		A	ALUM		10/A602	7/A601	6/A601		03			PANIC HARDWARE
102.1		3'-0"	7'-0"	4	ALUM		A	ALUM		2/A602	7/A601	6/A601		04		•	PANIC HARDWARE
102.2	PR	8'-0"	7'-0"	4	ALUM		A	ALUM		2/A602	7/A601	6/A601		08			PANIC HARDWARE
102.3		3'-0"	7'-0"	4	ALUM		A	ALUM		2/A602	7/A601	6/A601		07			PANIC HARDWARE
102.4	PR	6'-0"	7'-0"	4	ALUM		A	ALUM		8/A602	7/A602	6/A601		06			PANIC HARDWARE
102.5	PR	6'-0"	7'-0"	4	ALUM		A	ALUM		8/A602	7/A602	6/A601		05		•	PANIC HARDWARE
103.1		3'-0"	7'-0"	4	ALUM		A	ALUM		2/A602	7/A601	6/A601		07			PANIC HARDWARE
103.2	PR	8'-0"	7'-0"	4	ALUM		A	ALUM		2/A602	7/A601	6/A601		08			PANIC HARDWARE
103.3		3'-0"	7'-0"	4	ALUM		A	ALUM		2/A602	7/A601	6/A601		07			PANIC HARDWARE
103.4	PR	6'-0"	7'-0"	4	ALUM		A	ALUM		8/A602	7/A602	6/A601		06		•	PANIC HARDWARE
103.5	PR	6'-0"	7'-0"	4	ALUM		A	ALUM		8/A602	7/A602	6/A601		06			PANIC HARDWARE
104.1		3'-0"	7'-0"	4	ALUM		A	ALUM		8/A602	7/A601	6/A601		03			PANIC HARDWARE
104.2	PR	8'-0"	7'-0"	4	ALUM		A	ALUM		8/A602	7/A601	6/A601		02		•	PANIC HARDWARE
104.3		3'-0"	7'-0"	4	ALUM		A	ALUM		8/A602	7/A601	6/A601		03			PANIC HARDWARE
106		3'-0"	7'-0"	2	WD	BIRCH NAT	A	HM		2/A601	1/A601	-		14			
107		3'-0"	7'-0"	2	WD	BIRCH NAT	A	HM		2/A601	1/A601	-		14			
108		3'-0"	7'-0"	2	WD	BIRCH NAT	A	HM		2/A601	1/A601	-		14			
109		3'-0"	7'-0"	2	WD	BIRCH NAT	A	HM		2/A601	1/A601	-		14			
110		3'-0"	7'-0"	3	WD	BIRCH NAT	A	HM		2/A601	1/A601	-		14			
111		3'-0"	7'-0"	3	WD	BIRCH NAT	A	HM		2/A602	1/A601	-		14			
112		3'-0"	7'-0"	1	HM		A	HM		2/A601	1/A601	-		10			PANIC HARDWARE
114.1		3'-0"	7'-0"	1	WD	BIRCH NAT	A	HM		2/A601	1/A601	-		14			
114.2		3'-0"	7'-0"	1	WD	BIRCH NAT	A	HM		2/A601	1/A601	-		15			PANIC HARDWARE
115.1	PR	6'-0"	7'-0"	2	HM		A	HM		2/A601	1/A601	-		11			PANIC HARDWARE
115.2	PR	6'-0"	7'-0"	2	HM		A	HM		5/A601	4/A601	3/A601		09		•	PANIC HARDWARE
116.1	PR	6'-0"	7'-0"	4	WD	BIRCH NAT	A	HM		2/A601	1/A601	-		12		•	PANIC HARDWARE
116.2	PR	6'-0"	7'-0"	2	HM		A	HM		5/A601	4/A601	3/A601		09		•	PANIC HARDWARE
117		3'-0"	7'-0"	1	WD	BIRCH NAT	A	HM		2/A601	1/A601	-		14			
118		3'-0"	7'-0"	1	WD	BIRCH NAT	A	HM		2/A601	1/A601	-		17			
122		3'-0"	7'-0"	1	WD	BIRCH NAT	A	HM		2/A601	1/A601	-		18			
123		3'-0"	7'-0"	1	WD	BIRCH NAT	A	HM		2/A601	1/A601	-		15			
124		3'-0"	7'-0"	1	WD	BIRCH NAT	A	HM		2/A601	1/A601	-		14			
125		3'-0"	7'-0"	3	WD	BIRCH NAT	A	HM		2/A601	1/A601	-		14			
126	PR	6'-0"	7'-0"	4	WD	BIRCH NAT	A	HM		2/A601	1/A601	-		12		•	PANIC HARDWARE
127		3'-0"	7'-0"	3	WD	BIRCH NAT	A	HM		2/A601	1/A601	-		14			
128		3'-0"	7'-0"	3	WD	BIRCH NAT	A	HM		2/A601	1/A601	-		14			
129		3'-0"	7'-0"	3	WD	BIRCH NAT	A	HM		2/A601	1/A601	-		14			
130		3'-0"	7'-0"	3	WD	BIRCH NAT	A	HM		2/A601	1/A601	-		14			
131		3'-0"	7'-0"	1	HM		A	HM		60	9/A601	8/A601	-		16		

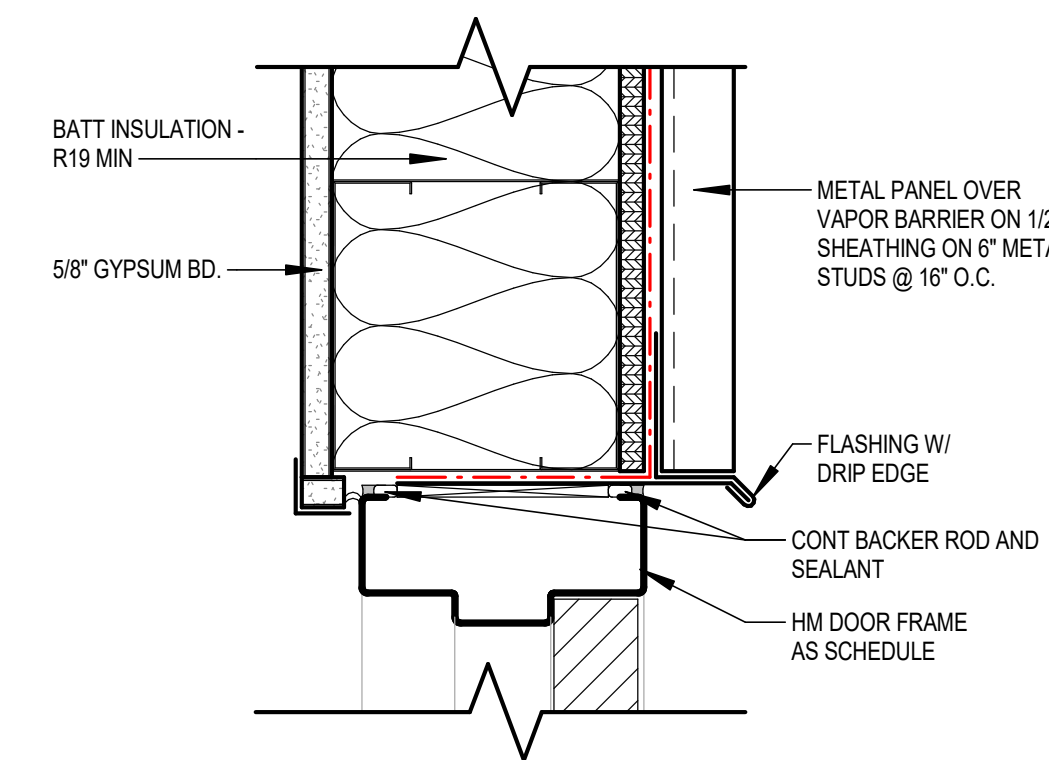


5 HEAD DETAIL
3" = 1'-0"

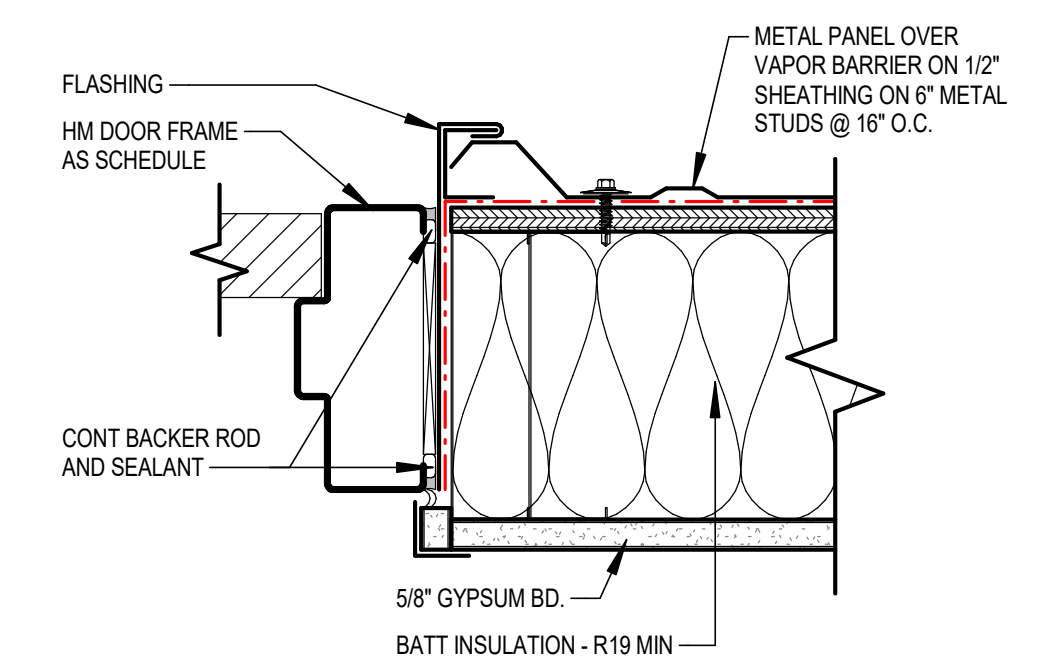


4 JAMB DETAIL
3" = 1'-0"

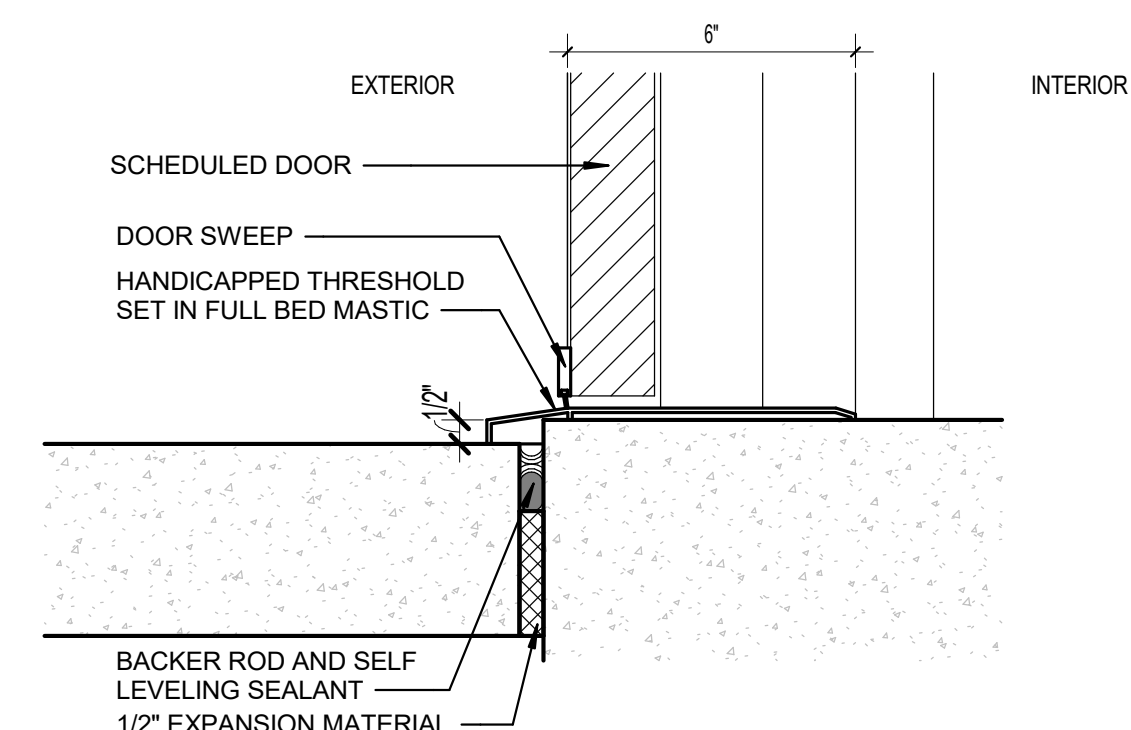


3 SILL DETAIL
3" = 1'-0"

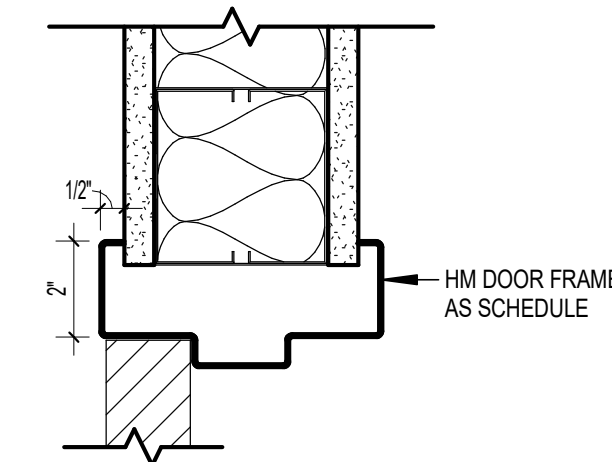


2 HEAD DETAIL
3" = 1'-0"

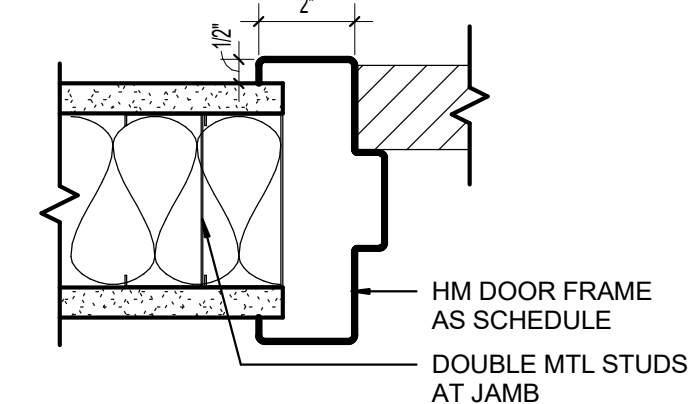


1 JAMB DETAIL
3" = 1'-0"

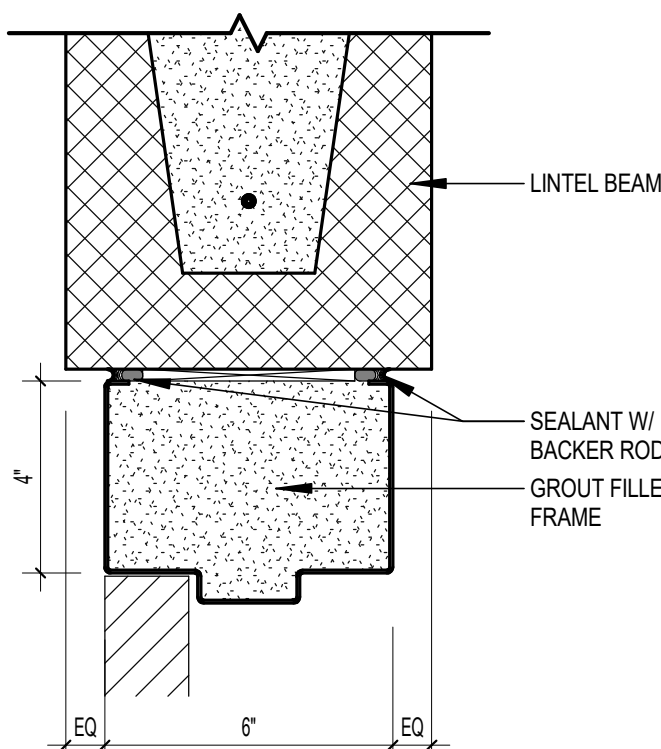


9 HEAD DETAIL
3" = 1'-0"

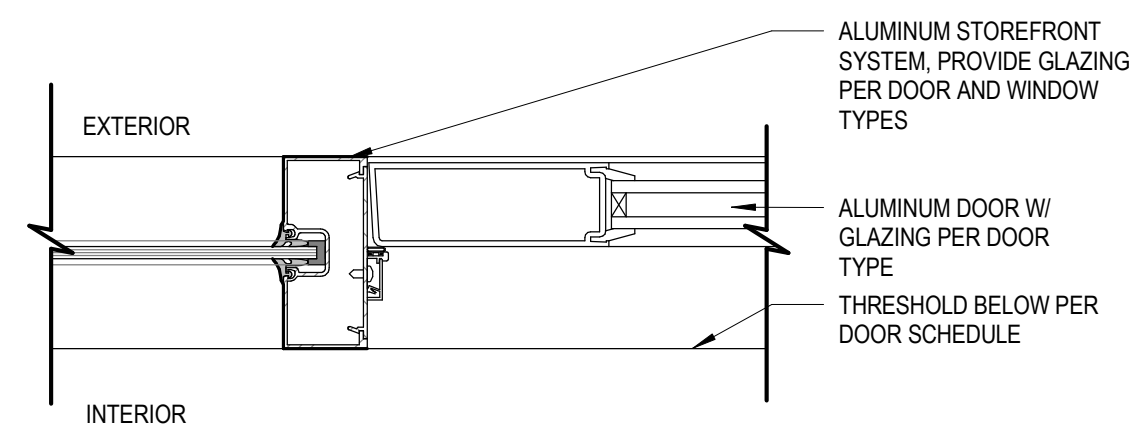

7 STOREFRONT DETAIL AT HEAD AND JAMB
3" = 1'-0"

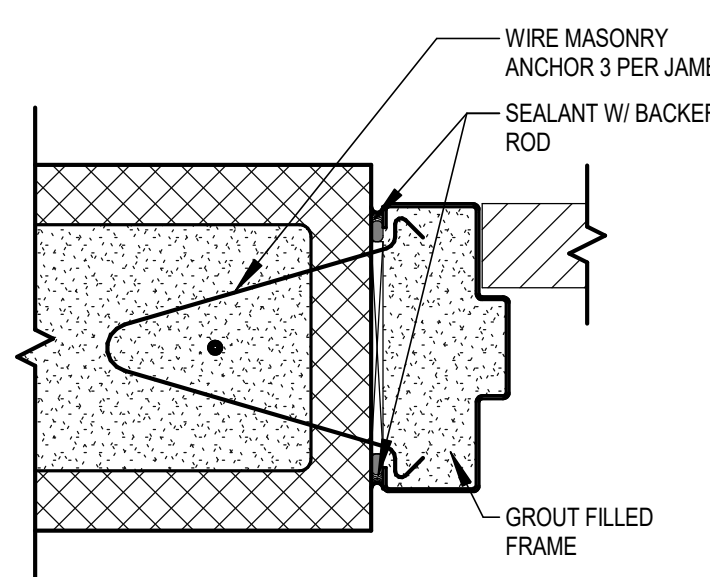

8 JAMB DETAIL
3" = 1'-0"

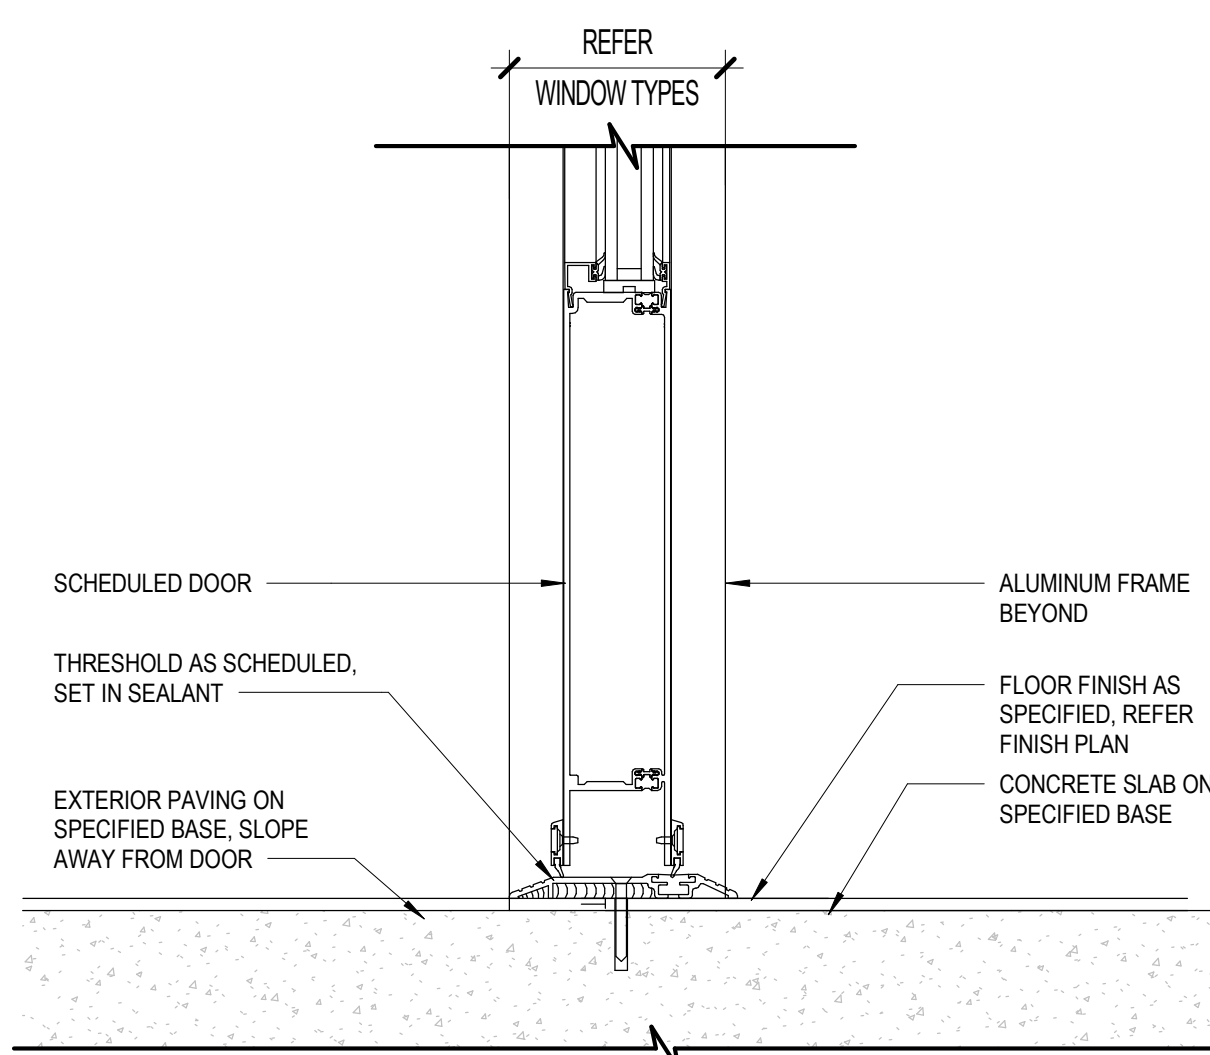

6 STOREFRONT DETAIL AT THRESHOLD
3" = 1'-0"

100% CONSTRUCTION
DOCUMENTS
03.03.2025

EVERGREEN BAPTIST CHURCH - PHASE 5

10301 EAST 111TH ST. S.
BROKEN ARROW, OKLAHOMA 74011

REVISIONS

1 03.19.2025 ADD#1

DOOR AND DOOR FRAME SCHEDULES AND DETAILS

JOB 2023.14

ISSUE 03.03.2025

DRAWN BY: BG

CHKD BY: SE

A601

SCALE As indicated

SPECIALTIES SCHEDULE							
MARK	DESCRIPTION	MANUFACTURER	PRODUCT NO.	DIMENSIONS	FINISH	COMMENTS	RESPONSIBILITY
DIVISION 8 - MIRRORS AND GLAZING							
M1	MIRROR	AMERICAN SPECIALTIES, INC.		18" W x 24" H x 3/4" D	STAINLESS STEEL	THEFT RESISTANT	CFCI
M2	MIRROR	AMERICAN SPECIALTIES, INC.		36" W x 48" H x 3/4" D	STAINLESS STEEL	THEFT RESISTANT	CFCI
DIVISION 10 - COMMERCIAL/RESIDENTIAL APPLIANCES							
CPR1	COPIER	-		-	-	TBD BY OWNER	OFOI
LKR1	LOCKER	AMERICAN STORAGE SOLUTIONS, INC.		12" W x 12" D x 72" H	CHARCOAL #23	DOUBLE TIER, WITH FRONT & CLOSED END BASE AND CONTINUOUS SLOPE HOOD	CFCI
DIVISION 10 - FIRE PROTECTION SPECIALTIES							
FEC	FIRE EXTINGUISHER CABINET	LARSEN	2409R7	9 1/2" x 24" x 6"	-	[WITH 10b ABC, M10	CFCI
DIVISION 10 - TOILET AND BATH ACCESSORIES							
BCS1	BABY CHANGING STATION	-	-	-	PLASTIC	SURFACE MOUNTED, BASIS OF DESIGN KOALA KARE, KB200	CFCI
GB18	GRAB BAR 18"	AMERICAN SPECIALTIES, INC.	3801-18	1-1/2" x 1'-6"	STAINLESS STEEL	SURFACE MOUNTED	CFCI
GB24	GRAB BAR 24"	AMERICAN SPECIALTIES, INC.	3801-24	1-1/2" x 2'-0"	STAINLESS STEEL	SURFACE MOUNTED	CFCI
GB36	GRAB BAR 36"	AMERICAN SPECIALTIES, INC.	3801-36	1-1/2" x 3'-0"	STAINLESS STEEL	SURFACE MOUNTED	CFCI
GB42	GRAB BAR 42"	AMERICAN SPECIALTIES, INC.	3801-42	1-1/2" x 3'-6"	STAINLESS STEEL	SURFACE MOUNTED	CFCI
SD1	SOAP DISPENSER	AMERICAN SPECIALTIES, INC.	0347	4" x 8" x 3"	STAINLESS STEEL	SURFACE MOUNTED	CFCI
SD1	SANITARY NAPKIN DISPOSAL	BRADLEY	MODEL 4721-15	12 3/4" L x 17-1/8" H x 4"D	STAINLESS STEEL	PARTITION MOUNTED - SERVES 2 COMPARTMENTS	CFCI
TD1	TOWEL DISPENSER	KIMBERLY-CLARK	9603	13.31" W X 18.85" H X 5.85" D	CHARCOAL GRAY	SURFACE MOUNTED	CFCI
TTD1	TOILET TISSUE DISPENSER	AMERICAN SPECIALTIES, INC.	0040	20 1/2" L x 11-3/16" H x 4-11/16" D	STAINLESS STEEL	SURFACE MOUNTED	CFCI
DIVISION 10 - TOILET COMPARTMENTS							
TP1	TOILET PARTITION	SCRANTON PRODUCTS	HINY HIDERS	-	HDPE, MOCHA, ORANGE PEEL	FLOOR MOUNTED/OVERHEAD BRACED	CFCI
US1	URNAL SCREEN	SCRANTON PRODUCTS	HINY HIDERS	-	HDPE, MOCHA, ORANGE PEEL	WALL MOUNTED	CFCI
DIVISION 10 - WALL AND DOOR PROTECTION							
CG1	CORNER GUARDS	SEELYE CRAFTSMEN CO., INC.	-	-	STAINLESS STEEL	SURFACE MOUNTED	CFCI

INTERIORS / FINISHES NOTES

1. REFER TO NORTH DIRECTIONAL ARROWS ON PLANS.
2. HOLLOW METAL DOORS, FRAMES & INTERIOR WINDOW FRAMES (NEW & EXISTING) SHALL BE PAINTED PT2, UNLESS OTHERWISE NOTED.
3. ALL FINISHES IN EXITS SHALL BE CLASS A RATED. ALL FINISHES IN CORRIDORS SHALL BE CLASS A OR CLASS B RATED.
4. THE FOLLOWING SHALL BE PAINTED UNLESS OTHERWISE STATED:

A. EXPOSED SPRINKLER PIPING, ELECTRICAL CONDUIT, AND WIRE MOLDS IN FINISHED AREAS.

B. EXPOSED DUCTWORK IN FINISHED AREAS.

C. EXPOSED BEAMS, JOISTS, DECK, AND COLUMNS IN FINISHED AREAS.

D. INTERIOR LINTELS.

E. INTERIOR HANDRAILS & GUARDRAILS.

F. INTERIOR STEEL LADDERS, EP-PT1, TYP.


G. EXPOSED CEILING IN ROOM 227 TO BE PAINTED PT9 ABOVE 11'-7".
5. EXPOSED CEILINGS SHALL BE PAINTED PT1, UNLESS OTHERWISE NOTED.
6. REFER TO INTERIOR / FINISH PLANS FOR FLOOR FINISH PATTERNS AND DETAILS.
7. REFER TO INTERIOR ELEVATIONS FOR ADDITIONAL WALL FINISH INFORMATION.
8. CEILING, FLOORS, AND WALLS IN FOOD PREPARATION AND SERVING AREAS SHALL BE WASHABLE.
9. PAINT EXPOSED COLUMNS, TO MATCH ADJACENT WALLS, UNLESS OTHERWISE NOTED.
10. PAINT PT6 AT ALL EXPOSED SURFACES AND EDGES OF BALCONY AND STAIR GUARD RAIL, HANDRAIL, STRINGERS, AND UNDERSIDE OF TREADS AND RISERS.
11. NO EXPOSED RAW TILE EDGES. REFER TO FINISH & MATERIAL LEGEND FOR TRANSITIONS.
12. WATERJET CUT LVT FLOORING AT CLASSROOM ENTRANCES AND CHECK-IN FOR SEAMLESS CURVED DESIGN.

INTERIORS COMMENTS

1. INSTALL LVT1/4 DROP
2. INSTALL CARPET BASKETWEAVE.
3. INSTALL CARPET ASHLAR
4. INSTALL CARPET BRICK
5. INSTALL FLOOR TILE 1/3 OFFSET


FINISH & MATERIAL LEGEND

MARK	DESCRIPTION
WALK-OFF CARPET	
WCPT1	MILLIKEN; COLLECTION: OBEX; STYLE: CUT/PIZZ; COLOR: GREY FZC27-173; SIZE: 500M X 500M
CARPET	
CPT1	MANNINGTON; COLLECTION: PAPER; SERIES: CREASED PAPER; COLOR: GRASS 42231; SIZE: 18" x 36"
CPT2	MANNINGTON; COLLECTION: PAPER; SERIES: TORN PAPER; COLOR: LINEN 83228; SIZE: 18" x 36"
CPT3	MOHAWK; COLLECTION: NEW BASICS III TILE - BT400; COLOR: BISCOTTI CRUNCH 837; SIZE: 24" x 24"
CPT4	MILLIKEN; COLLECTION: NORDIC STORIES - TECTONIC; COLOR: CRYSTAL CAVE; SIZE: 25CM X 1M
CPT5	MANNINGTON; COLLECTION: GOOGIE; STYLE: PHENOMENA; COLOR: RETROSCOPE 83636; SIZE: BROADLOOM
RESILIENT FLOORING	
LV1	MILLIKEN; COLLECTION: THE MAGIC HOUR - PERSPECTIVE; COLOR: AMBIENT; SIZE: 25CM X 1.5M
LV2	MILLIKEN; COLLECTION: THE MAGIC HOUR - PERSPECTIVE; COLOR: SILHOUETTE; SIZE: 25CM X 1.5M
CONCRETE	
SC1	SEALED CONCRETE; PROSOCCO SINGLE STEP OR EQUAL
TRANSITION STRIPS	
TR1	SCHLUTER; QUADEC; MATERIAL: BRUSHED ALUMINUM; INSTALLATION: INSTALL EDGE PROTECTION AT TOP EDGE OF TILE AND OUTSIDE CORNERS
TR2	SCHLUTER; SCHIENE; MATERIAL: BRUSHED ALUMINUM; INSTALLATION: CARPET AND TILE EDGES
TR3	SCHLUTER; DILEX-EHK; MATERIAL: BRUSHED ALUMINUM; INSTALLATION: INSIDE WALL CORNERS AND WALL TO FLOOR COVE BASE
TR4	SCHLUTER; RENO-TK; MATERIAL: BRUSHED STAINLESS STEEL; INSTALLATION: TILE TO LVT
TR5	TARKETT; JOHNSONITE WHEELED TRAFFIC TRANSITIONS; CTA - 63 - X; COLOR: 63 BURNT UMBER; INSTALLATION: WALK-OFF CARPET TO CARPET
TR6	TARKETT; JOHNSONITE WHEELED TRAFFIC TRANSITIONS; CTA - 63 - JL; COLOR: 63 BURNT UMBER; INSTALLATION: 1/4" MATERIAL TO SUBFLOOR
BASE	
RB1	RUBBER BASE; TARKETT; TRADITIONAL VINYL 4"; COLOR: 63 BURNT UMBER
TILE	
T1	CROSSVILLE; COLOR BLOX 2.0; COLOR: SLUNKY; SIZE: 12" X 24"; FINISH: UNPOLISHED; GROUT: LATICRETE 88 SILVER SHADOW
T2	CROSSVILLE; COLOR BLOX 2.0; COLOR: SANDBOX; SIZE: 12" X 24"; FINISH: UNPOLISHED; GROUT: LATICRETE 88 SILVER SHADOW
T3	CROSSVILLE; COLOR BLOX 2.0; COLOR: SANDBOX; SIZE: 4" x 12"; FINISH: UNPOLISHED; VERIFY WITH MANUFACTURER FOR LEAD TIME; GROUT: LATICRETE 88 SILVER SHADOW
T4	MATCH EXISTING TILE AT UNDER STAIR BENCHES
CEILING	
ACT1	ARMSTRONG; SUSPENDED ACOUSTICAL CEILING, COLOR & STYLE TO MATCH EXISTING; PRELUDE XL 15/16" EXPOSED TEE IN WHITE; GRID COLOR: WHITE
GYP1	GYPSUM BOARD CEILINGS; FINISH WITH LEVEL 4 FINISH, INCLUDING EXPOSED SIDES
PAINT	
PT1	SHERWIN WILLIAMS; COLOR: AGREEABLE GRAY SW7029
PT2	SHERWIN WILLIAMS; COLOR: GRAY MATTERS SW7066
PT3	SHERWIN WILLIAMS; COLOR: COCOON SW6173
PT4	SHERWIN WILLIAMS; COLOR: BLONDE SW6128
PT5	SHERWIN WILLIAMS; COLOR: ROYCROFT VELLUM SW2833
PT6	SHERWIN WILLIAMS; COLOR: TRICORN BLACK SW6258
PLASTIC LAMINATE	
PL1	WILSONART; COLOR: FLORENCE WALNUT 7993-38 FINE VELVET FINISH
SOLID SURFACE	
SS1	WILSONART; COLOR: CHILLED EARTH 9228SS
STAIN	
ST1	MINWAX; COLOR: CARBON MW409
ST2	WOOD STAIN, TO MATCH RVP2 FROM PHASE 3, FINISH WITH CLEAR POLYURETHANE PROTECTIVE COATING, SATIN FINISH

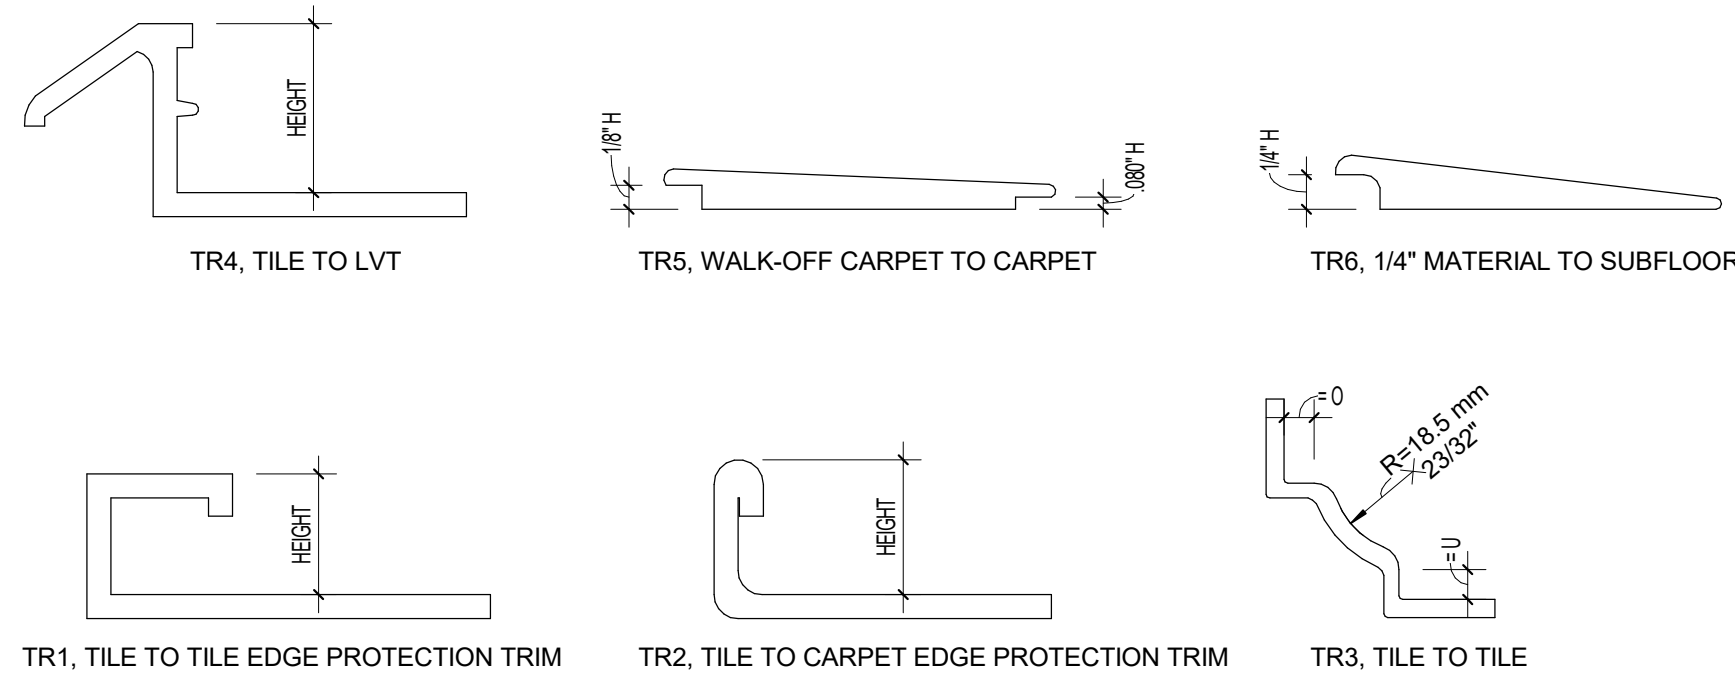

2 TRIM PROFILES

1 1/2" = 1'-0"

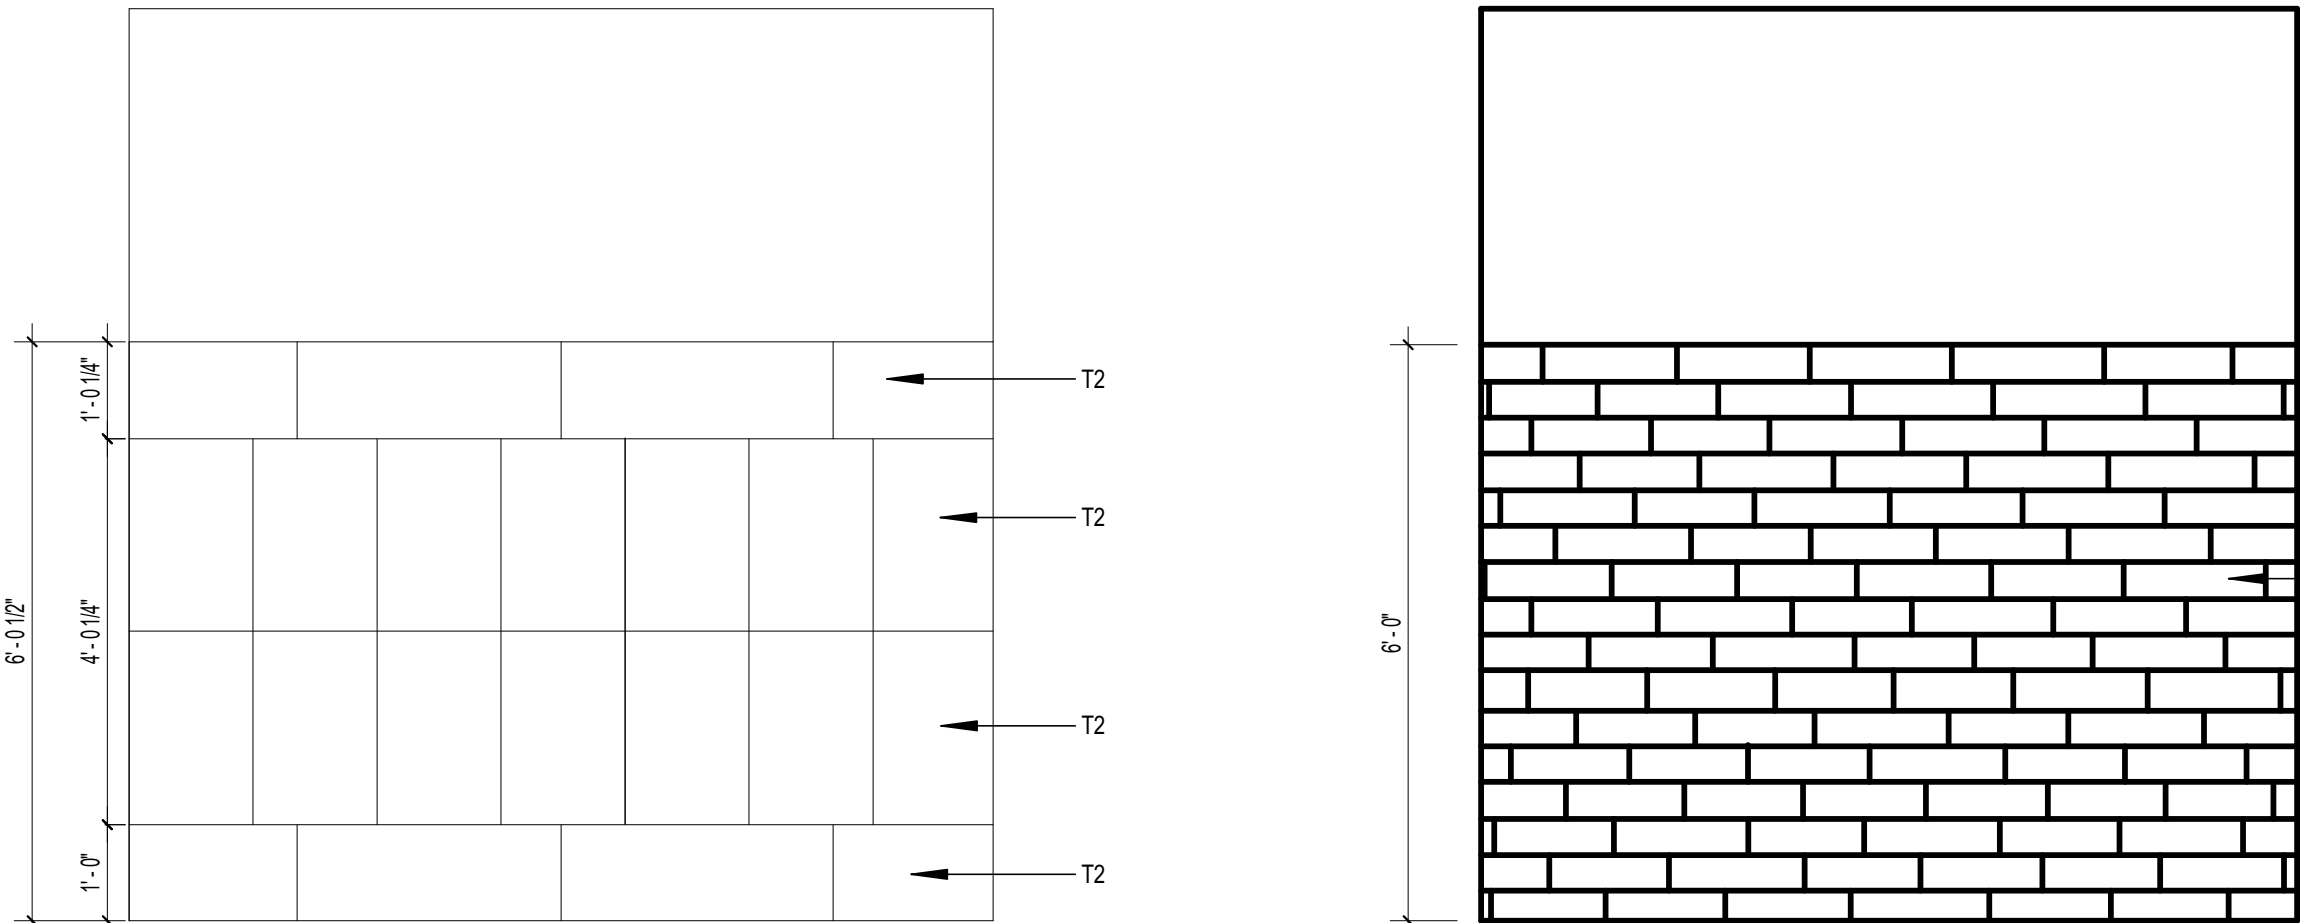

1 WALL TILE PATTERNS

1/2" = 1'-0"

CONSULTANT:

Reference Cover Sheet for Consultant Directory

100% CONSTRUCTION DOCUMENTS
03.03.2025

EVERGREEN BAPTIST CHURCH - PHASE 5

10301 EAST 111TH ST. S.
BROKEN ARROW, OKLAHOMA 74011

REVISIONS

1 03.19.2025 ADD#1

INTERIOR SCHEDULES

JOB 2023.14
ISSUE 03.03.2025

DRAWN BY: MW
CHKD BY: BG

A604

SCALE As indicated